





CABINETRY SPECIFICATIONS	KITCHEN PERIMETER	ISLAND	APPLIANCES	MAKE	MODEL	FINISH
COLLECTION: CONSTRUCTION: DOOR STYLE: DRAWER STYLE: WOOD SPECIES: FINISH: CARCASS: DRAWER BOX: DRAWER HARDWARE: DOOR HINGES: DOOR HINGE FINISH: DECORATIVE HARDWARE:	BENTWOOD FRAMELESS NOUVEAU NOUVEAU WALNUT CUSTOM-STAIN PRE-FIN. MAPLE PLY SOLID WOOD FULL EXT. SOFT CLOSE EURO CONCEALED N/A INTEGRATED ALUMINUM	BENTWOOD FRAMELESS BONN BONN KNOTTY WALNUT CUSTOM-STAIN & GLAZE PRE-FIN. MAPLE PLY SOLID WOOD FULL EXT. SOFT CLOSE EURO CONCEALED N/A	30" REFRIGERATOR 48" DUEL FUEL RANGE RED KNOB SET CUSTOM HOOD HOOD INSERT 24" FREEZER DRAWERS 60cm COFFEE SYSTEM 30" COFFEE TRIM KIT 60cm COMBI STEAM OVEN 30" STEAM OVEN TRIM KIT 30" WINE STORAGE WINE LOCK KIT 60cm DISHWASHER	SUB ZERO WOLF WOLF - BEST SUB ZERO MIELE MIELE MIELE MIELE SUB ZERO SUB ZERO MIELE	IC30RRH DF486GLP 804370 - CP571QT489SB ID24FI CVA6800SS EBA6808MC DGC68051XLSS EBA6808SS IW30ARLH 7028773 PG8133SCVI208	CABINET PANEL SS RED SS SS CABINET PANEL SS SS SS SS CABINET PANEL - CABINET PANEL
			**NOTE WINE STORAGE NEEDS TO BE HIGH ALTITUDE GLASS**			

<div>FIRE PREVENTION In; 7-20-21; Out; 7-20-21</div> <div>Conditionally Approved –NO INSPECTIONS deferred submittal until RECEIPT of Fire Alarm/Sprinkler plan/permits by sub-contractor to Fire Prevention. See www.steamboatspring s.net, Fire and EMS Services, Fire Prevention, Downloadable Permits and Forms</div>	<div>RCRBD Notes;</div> <div>1. separate electrical, plumbing, mechanical permits are required for work subject to permits within these trades.</div> <div>2. Field inspections apply to all walls/floors/ceilings that separate this unit from other units or corridors, and must be restored with the same materials applicable to the fire rating for this building, and inspected.</div>	PLUMING FIXTURES	MAKE	MODEL	FINISH
		MAIN FAUCET MAIN SINK AIR SWITCH  BOTTOM GRATES DIPSOSAL FLANGE/BASKET 18" UPPER DECK 12 UPPER DECK UTENSIL CADDY	GALLEY GALLEY GALLEY  GALLEY GALLEY GALLEY GALLEY GALLEY	IWT D GSS IWS4S WH IDS 1 GSS  BG4S2SS GDRNMSS UD-18-1WH UD-12-1WH UDO64	GUN METAL 316 L STAINLESS STEEL GUN METAL  STAINLESS STEEL STAINLESS STEEL WHITE WHITE WHITE  **NOTE - ACCESSORY COLORS TO BE VERIFIED AFTER ISLAND STONE IS SELECTED.**

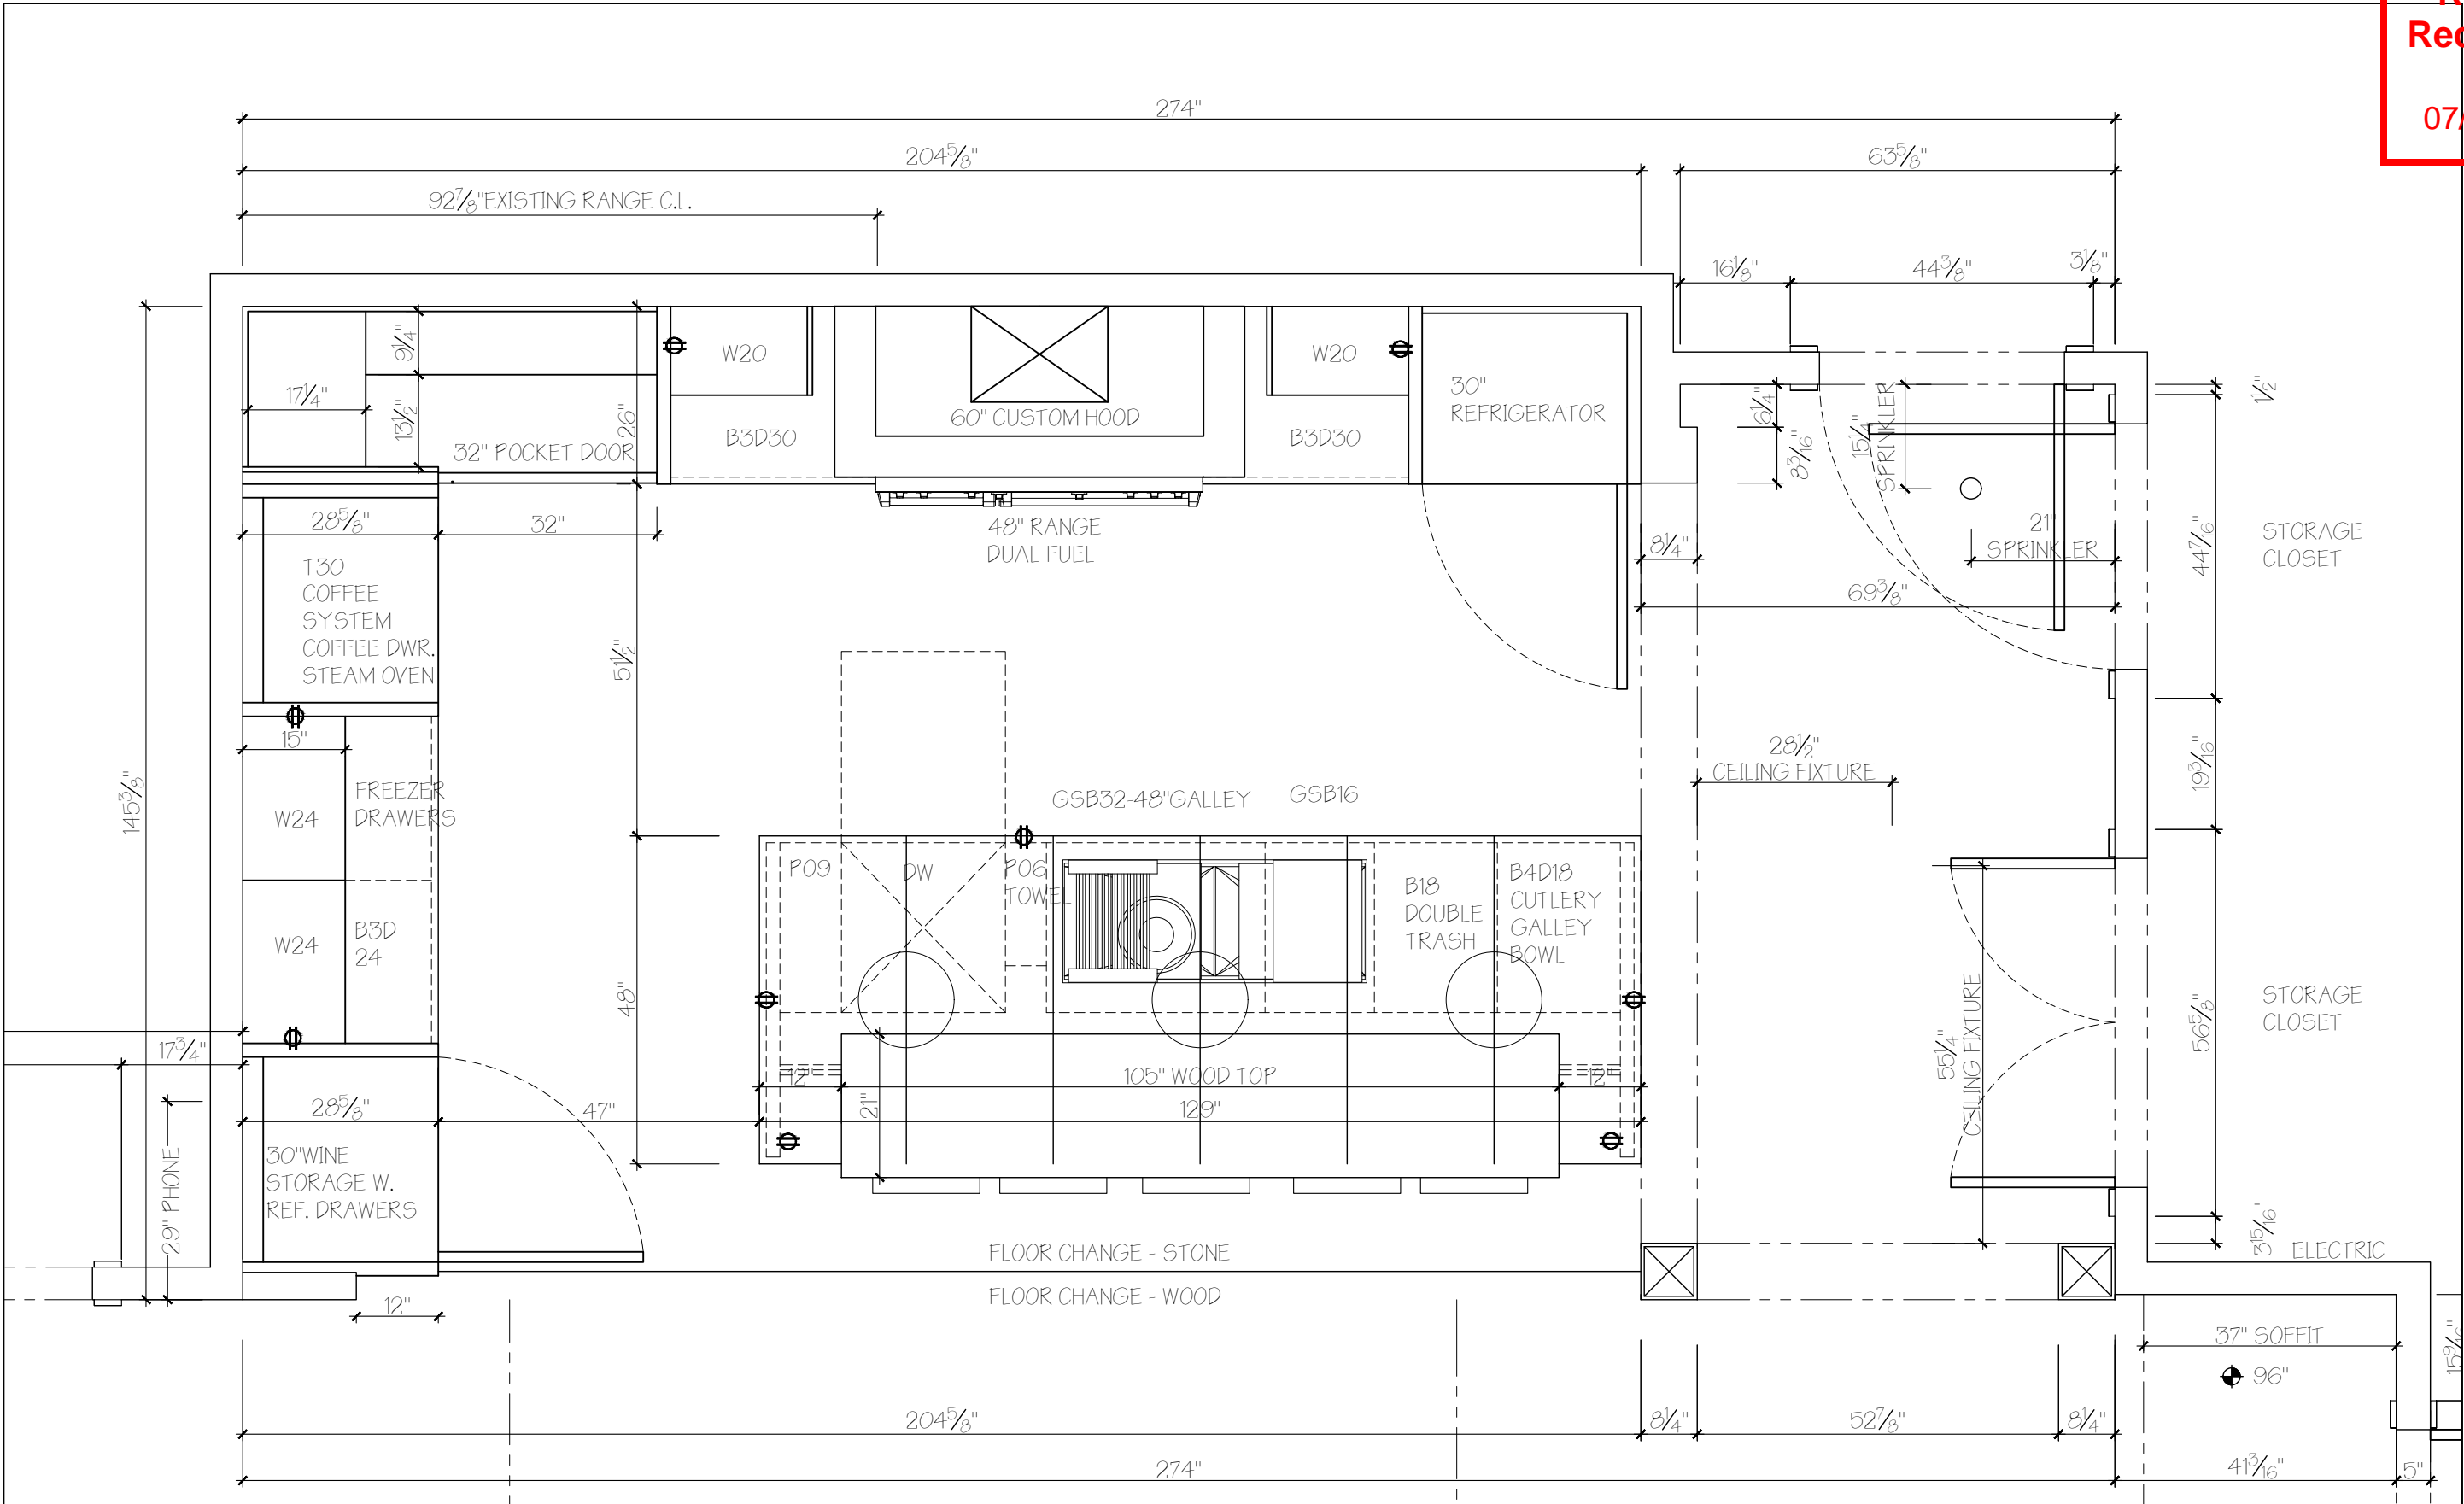

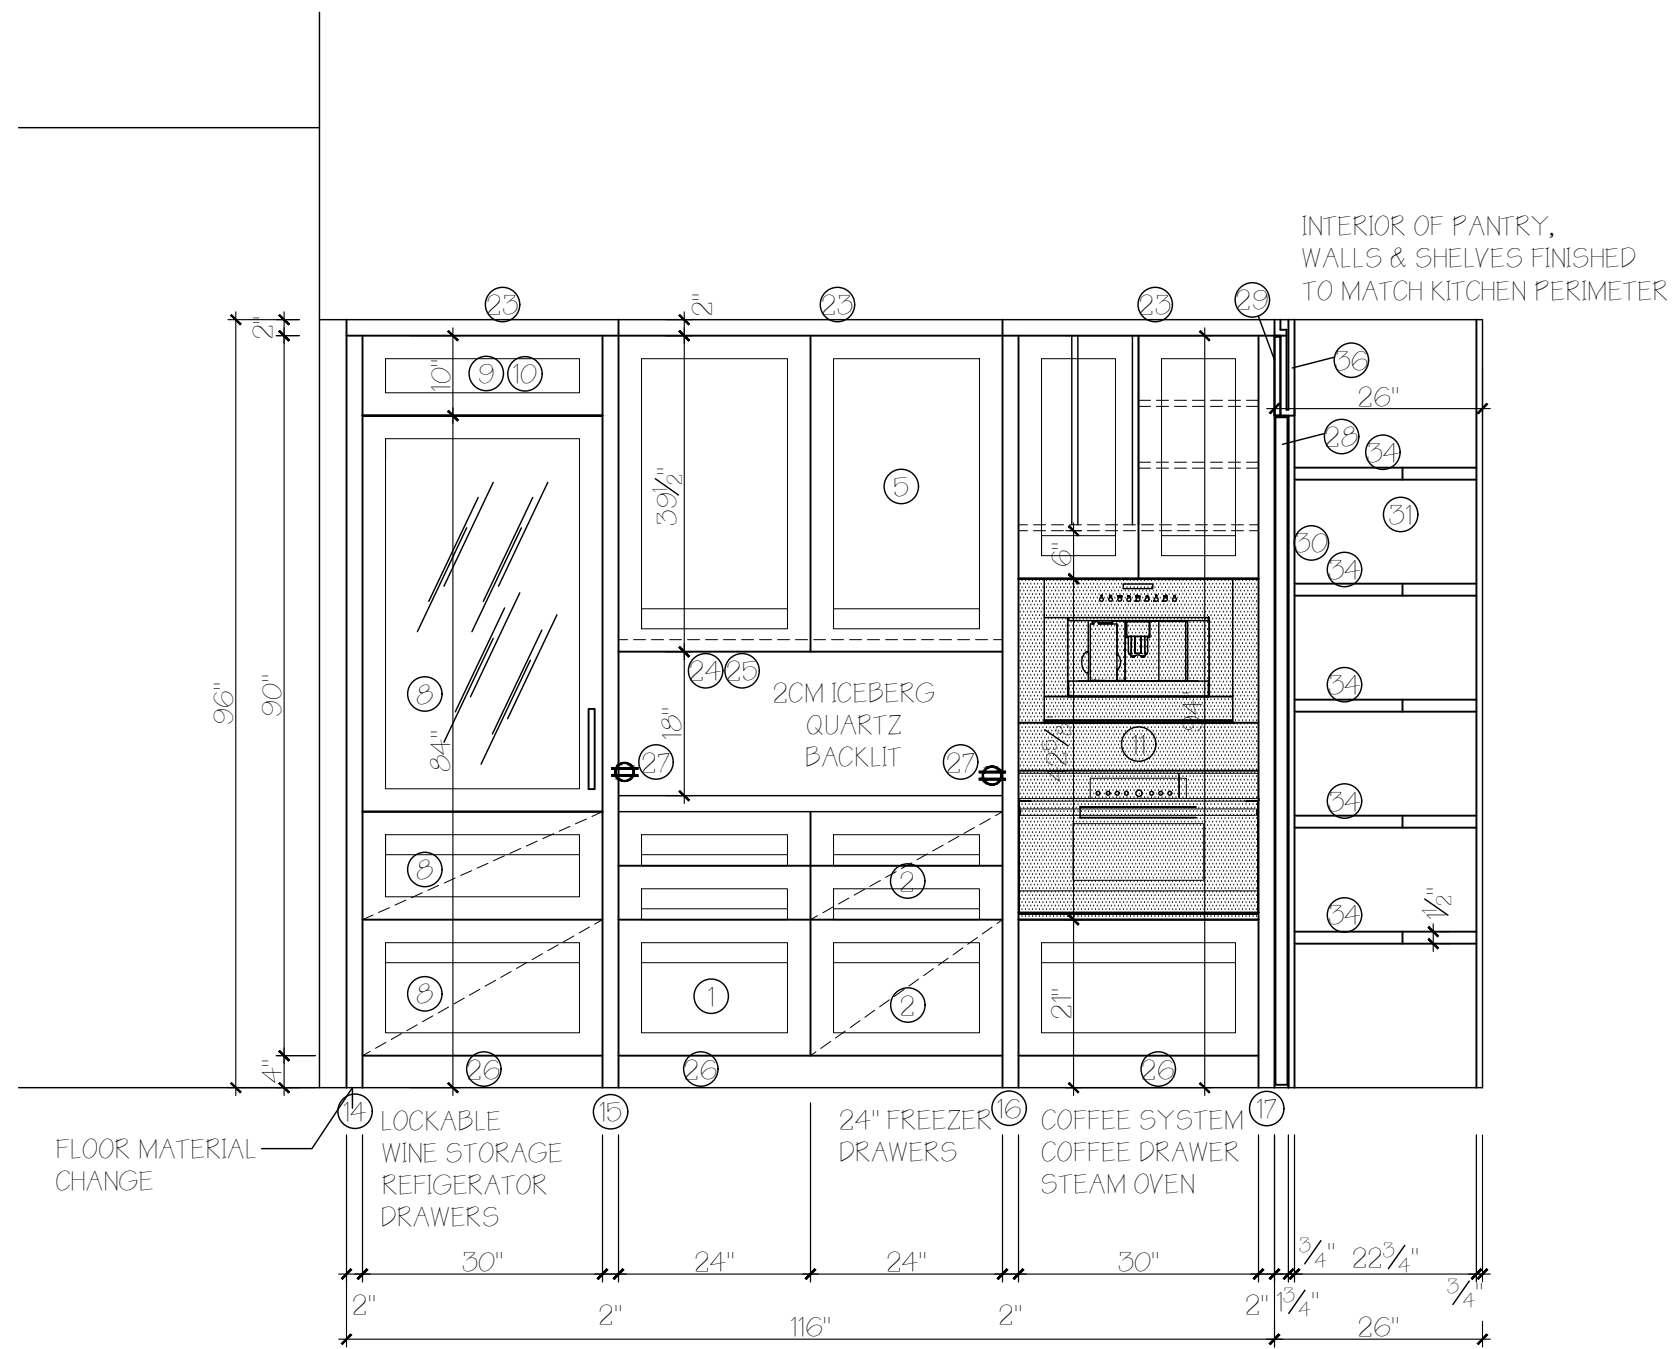

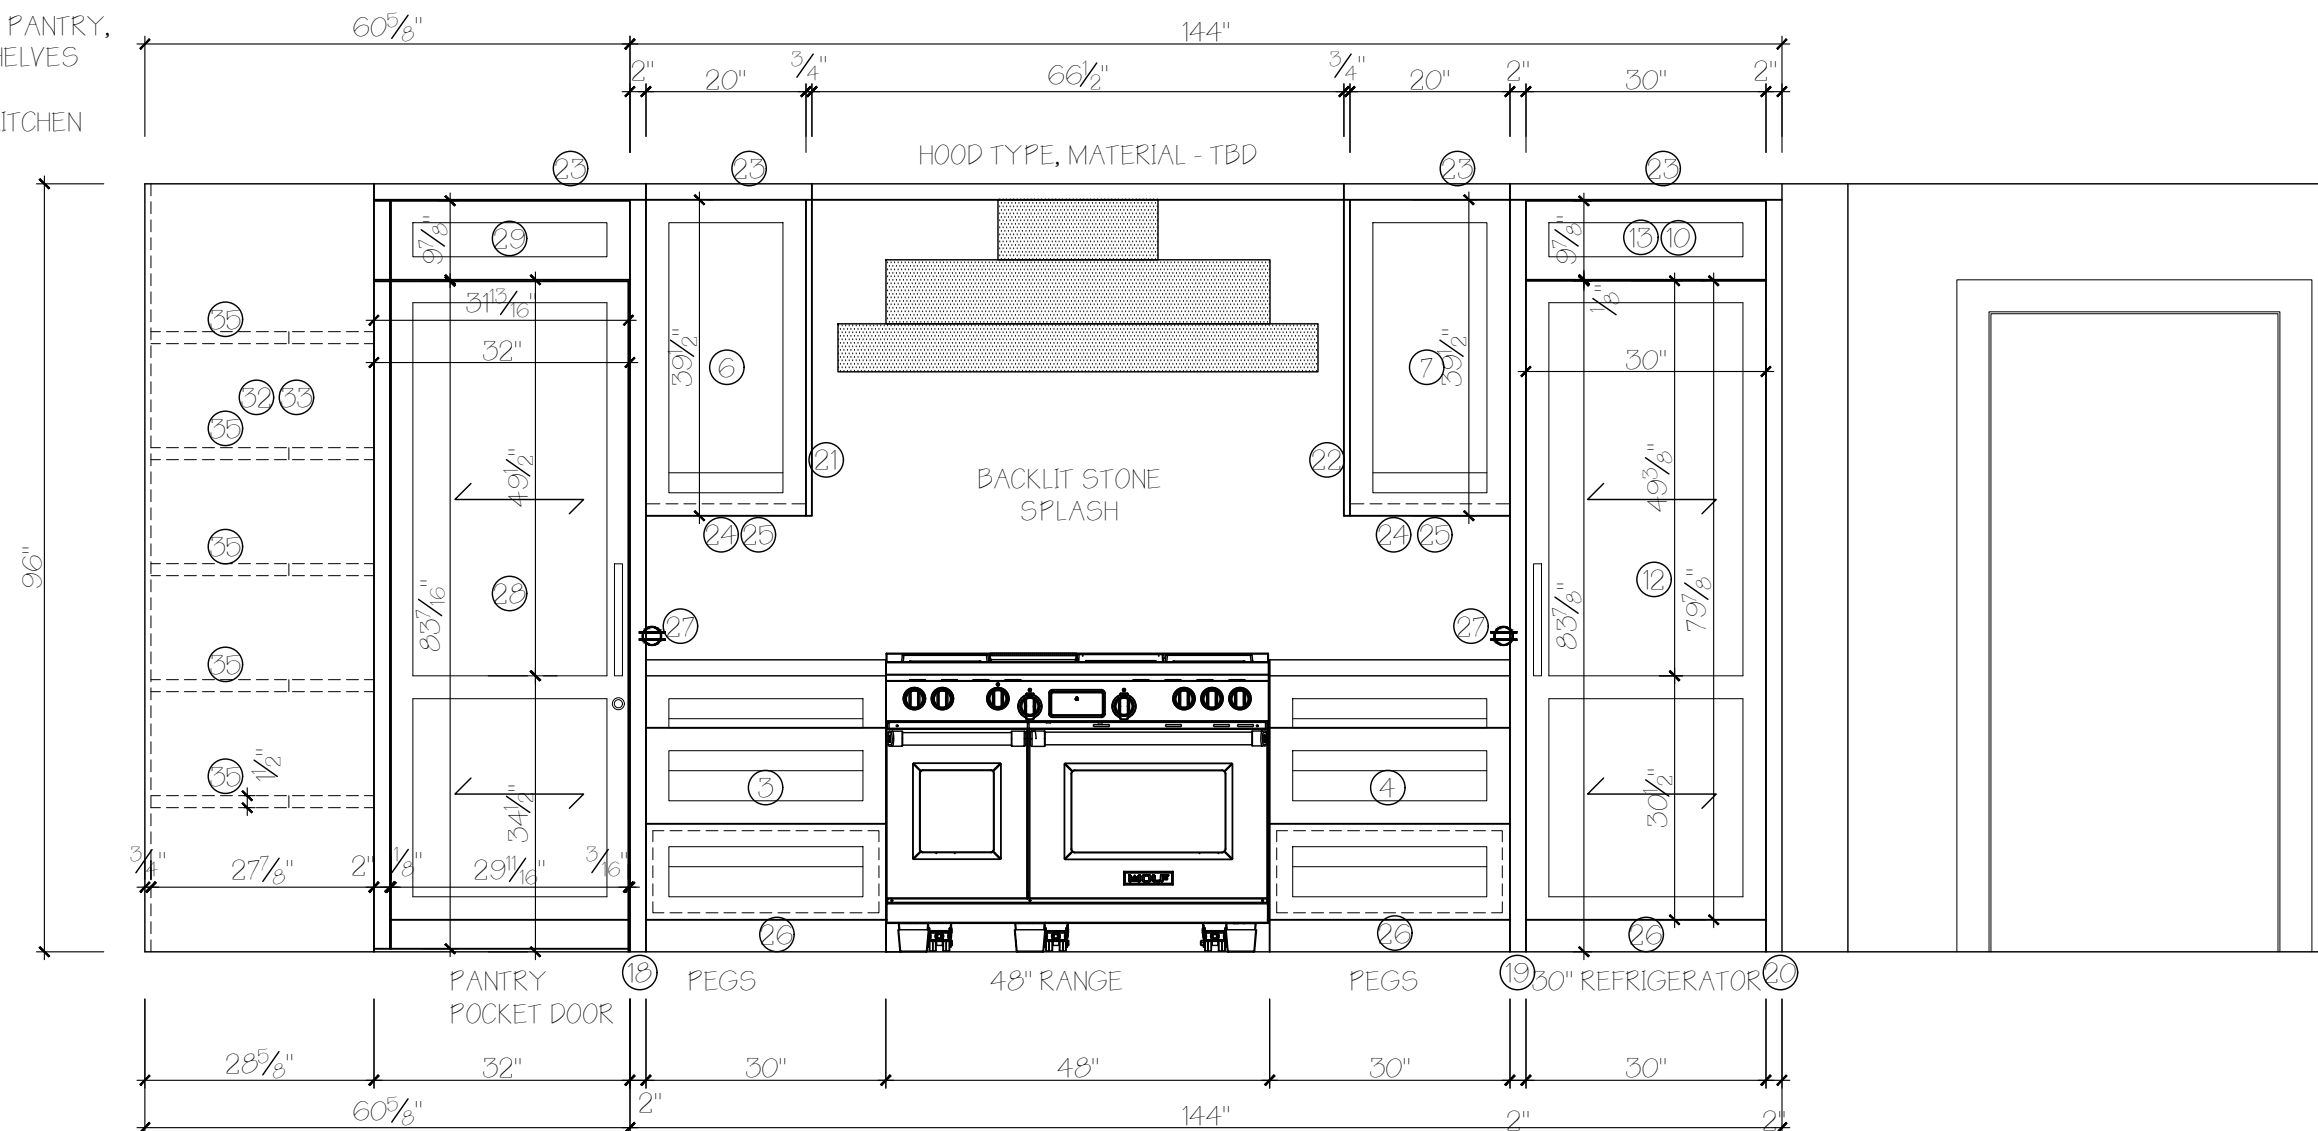

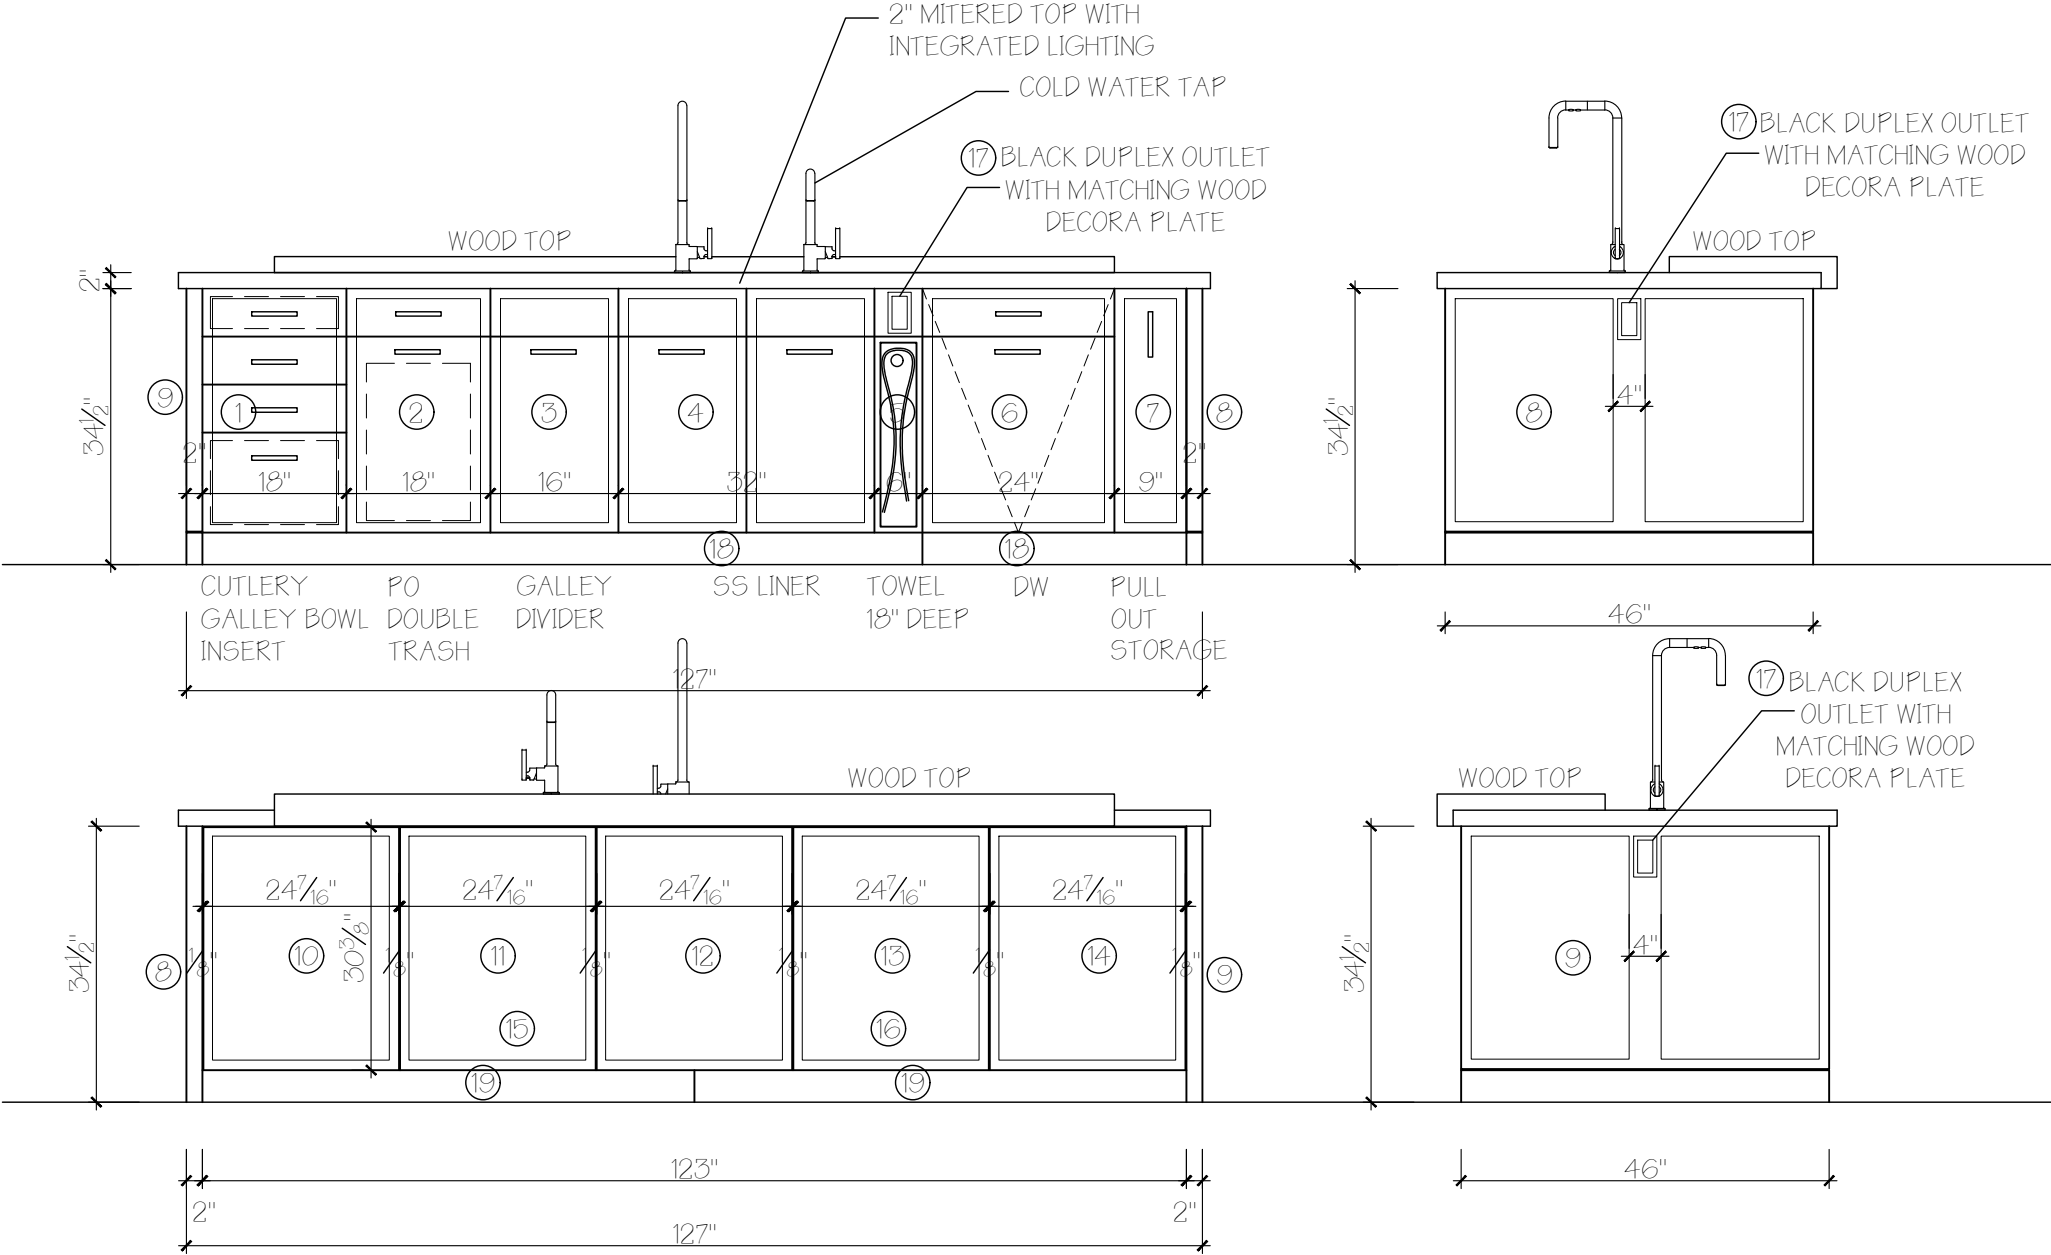

222 MERCHANDISE MART PLAZA  
SUITE #161  
CHICAGO, IL 60654  
312.321.1113

© 2014 DESIGN PLANS ARE PROVIDED FOR THE FAIR USE BY THE CLIENT OR HIS AGENT IN COMPLETING THE PROJECT AS LISTED IN THIS CONTRACT. DESIGN PLANS REMAIN THE PROPERTY OF BENTWOOD OF CHICAGO AND CANNOT BE USED OR REUSED WITHOUT PERMISSION.

ROSENSTEIN RESIDENCE  
2410 SKI TRAIL LANE  
STEAMBOAT SPRINGS, CO 80487

DATE/REVISIONS:
2.19.19
2.28.19
3.6.19
4.8.19
7.1.19

CONTRACT  
DRAWINGS

DESIGNER: STEVE KARP
DRAWN BY: SS
SCALE: 1/2"=1'-0"
ROOM: KITCHEN

A04