



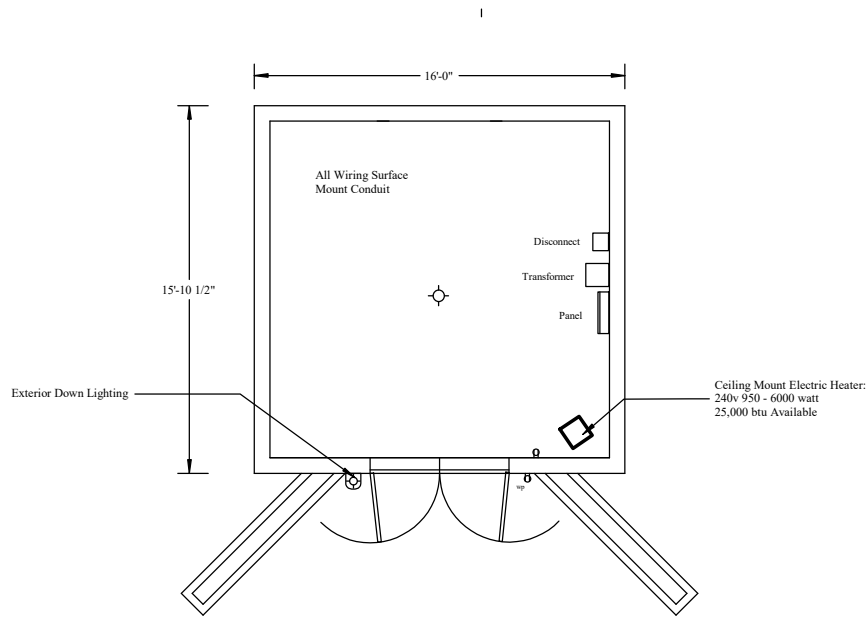

FLOOR PLAN

PANEL LOAD
240/120
OUTLETS - 540 VA
HEAT - 3000 VA
LIGHTS - 300 VA

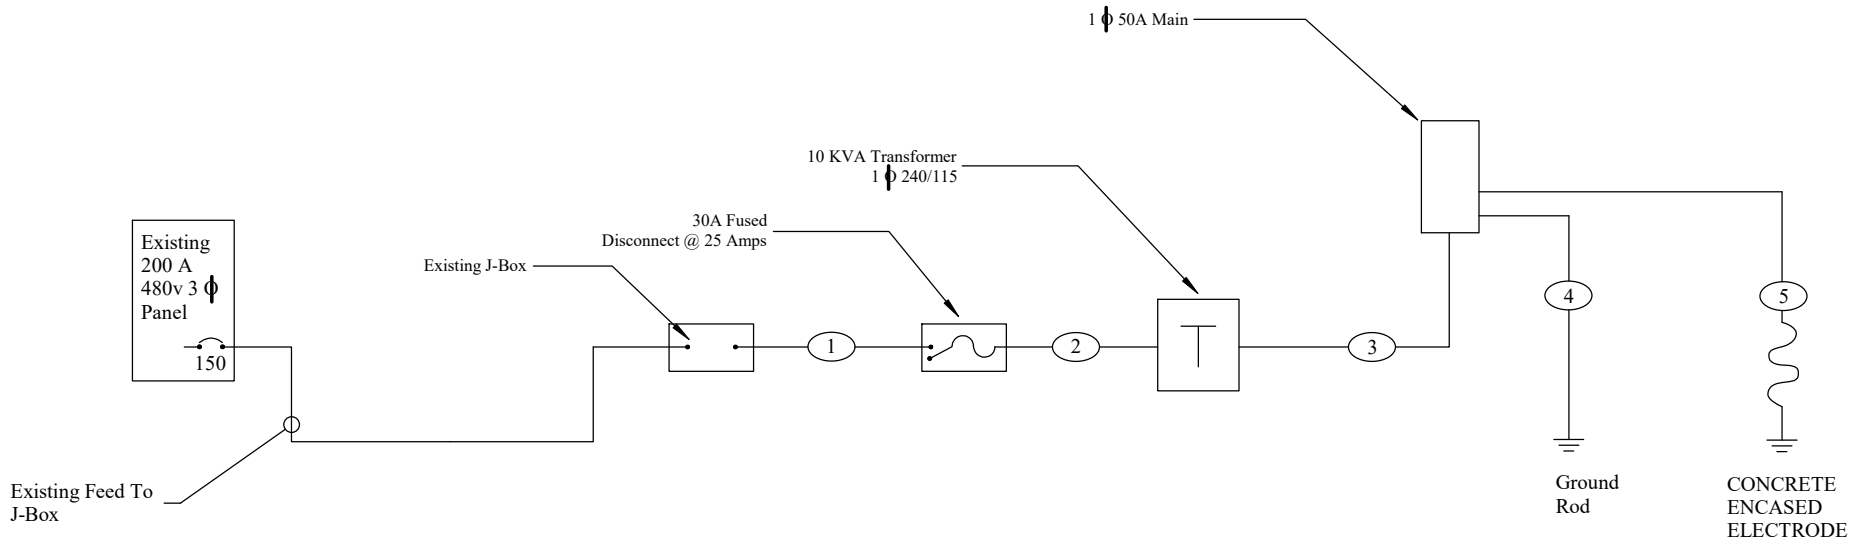

- ① - (3) #6 CU THWN, (1) #10 CU GRD
- ② - (3) #10 CU THWN
- ③ - (3) #6 CU, (1) #10 CU GRD
- ④ - (1) #6 CU GRD
- ⑤ - (1) #4 CU GRD

REVIEWED
FOR
CODE
COMPLIANCE
04/26/2022

TITLE: BASHOR BLOCKHOUSE ELECTRICAL			
SCALE: 1/4" = 1'	DESIGNED BY: VTS		
TEXT: 1.000	DATE: MAY 2021		
ARROW: 0.700	REVISED DATE: APRIL 2022		
OTHER: 0.250	FILE: bashbhelecE1.tcw		