

# STEAMBOAT CHRISTIAN CENTER

A New Residence for

821 DOUGHERTY ROAD  
TR IN SE4SW4 SEC 28-6-84, TOTAL 5 ACRES  
ROUTT COUNTY, CO




## PROJECT DESIGN TEAM

**ARCHITECTURAL**  
APEX ARCHITECTURE, PC  
P.O. BOX 771787  
STEAMBOAT SPRINGS, CO 80477  
PH: 720-934-9960  
CONTACT: BRIAN ADAMS

**STRUCTURAL**  
ALPENGLÖW ENGINEERING SOLUTIONS, INC  
1901 PINE GROVE RD, SUITE 202  
PO BOX 773501  
STEAMBOAT SPRINGS, CO 80477  
PH: 970-879-1181  
CONTACT: BEN SCHUTT

## VICINITY MAP

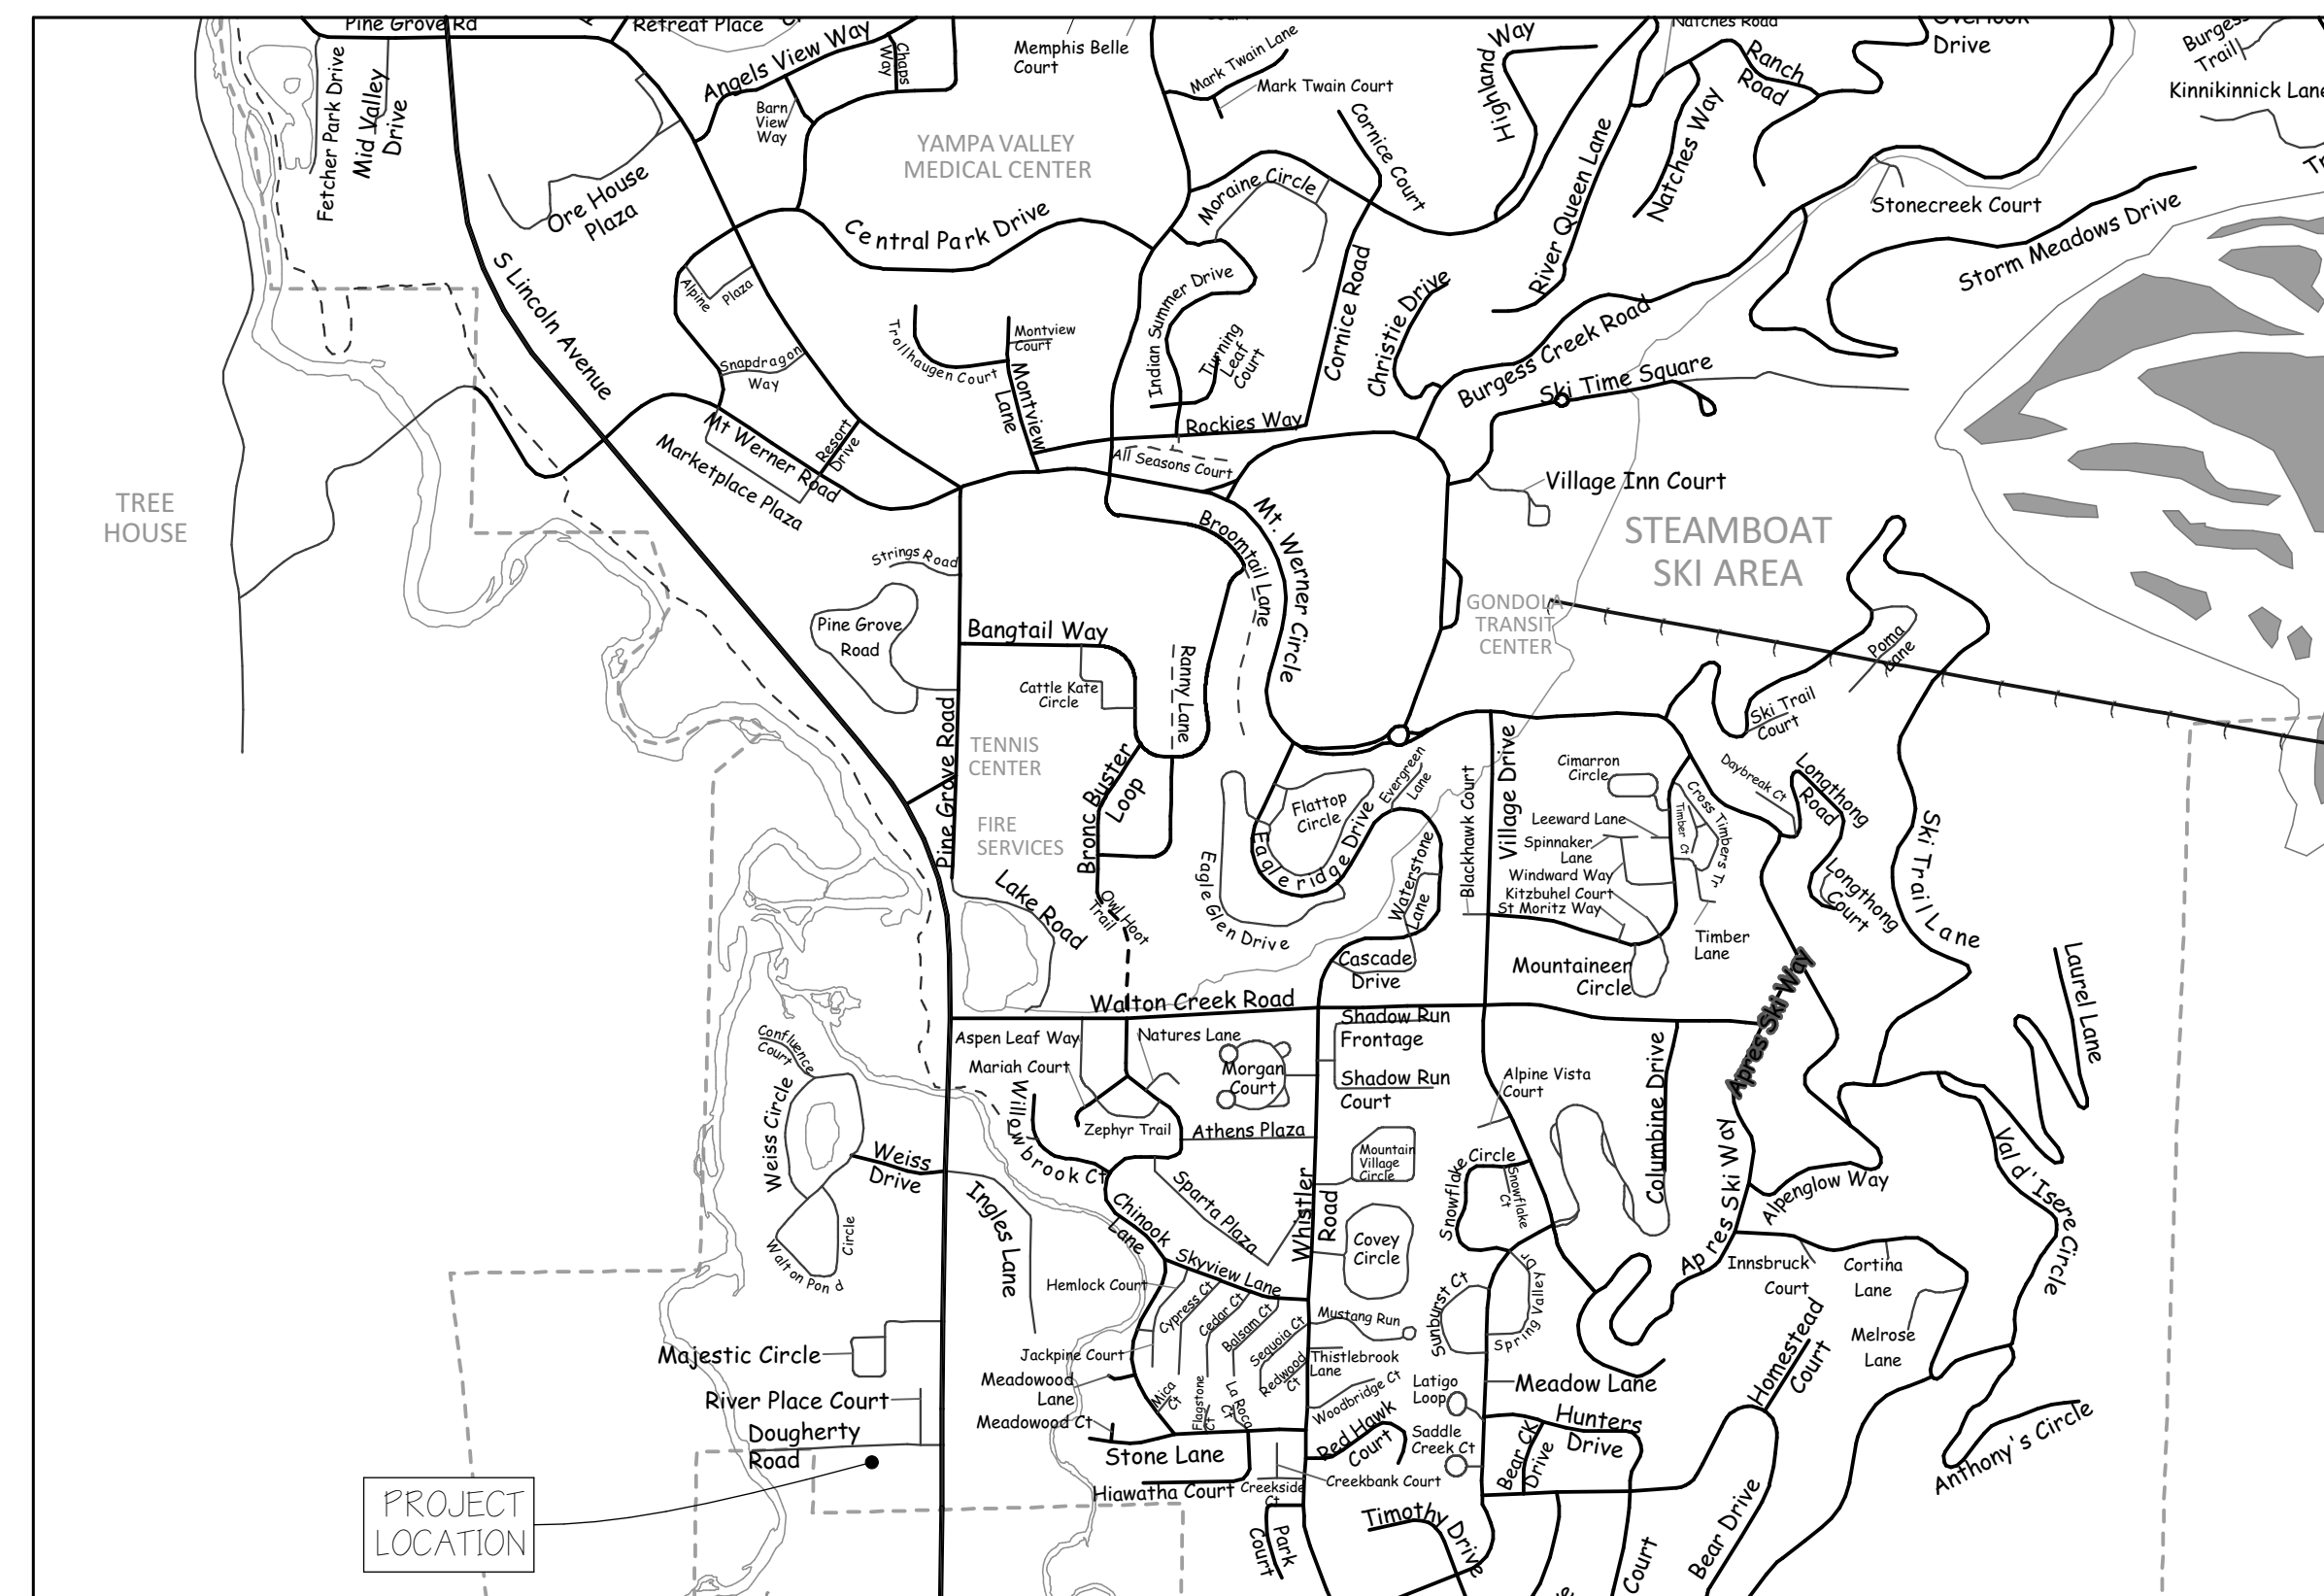


## SHEET INDEX

ID	SHEET TITLE	ISSUE	REV1	REV2
<b>ARCHITECTURAL</b>				
A0.0	TITLE SHEET	•	•	
A0.1	DRAWING NOTES	•	•	
A0.2	CODE ANALYSIS	•	•	
A1.0	SITE PLAN	•		
A2.0	DEMO MAIN LEVEL PLAN	•	•	
A2.1	NEW MAIN LEVEL PLAN	•	•	
A2.2	DEMO UPPER LEVEL PLAN	•	•	
A2.3	NEW UPPER LEVEL PLAN	•	•	
A2.4	NEW RCP AND LIGHTING PLAN	•		
A3.0	WEST ELEVATION	•	•	
A3.1	EAST ELEVATION	•	•	
A4.0	SECTIONS, SCHEDULES	•	•	
A4.1	DETAILS	•		
<b>STRUCTURAL</b>				
S-1	STRUCTURAL NOTES, FRAMMING PLANS	•		

NOTES:  
1) • INDICATES DATE OF MOST RECENT UPDATE TO SHEET.

**REVIEWED FOR  
CODE  
COMPLIANCE**  
02/22/2023

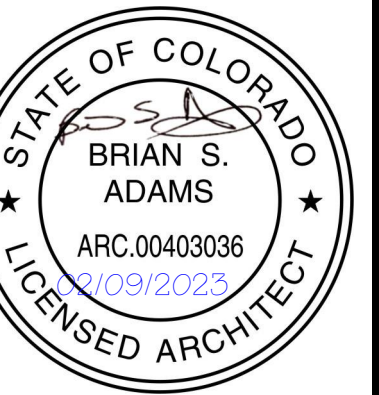

A Remodel for  
**STEAMBOAT CHRISTIAN CENTER**  
821 DOUGHERTY ROAD  
TR IN SE4SW4 SEC 28-6-84, TOTAL 5 ACRES  
STEAMBOAT SPRINGS  
ROUTT COUNTY, CO

REVISIONS:

CURRENT REVISION: 00

NO.	DATE	CHANGE

ISSUE DATE: 01/11/2023  
PERMIT

PROJECT NO: 21019

SHEET TITLE:  
TITLE SHEET

SHEET NO:

A0.0  
Sheet 1 of 13





A Remodel For  
**STEAMBOAT CHRISTIAN CENTER**  
 821 DOUGHERTY ROAD  
 TR IN SE4SW4 SEC 28-G-84, TOTAL 5 ACRES  
 STEAMBOAT SPRINGS  
 ROUTT COUNTY, CO

REVISIONS:

NO.	DATE	CHANGE
01	01/11/2023	FOR PERMIT

ISSUE DATE: 01/11/2023 PERMIT  
 PROJECT NO: 21019  
 SHEET TITLE: CODE ANALYSIS  
 SHEET NO: A0.2  
 Sheet 3 of 13

CODE ANALYSIS UPDATE WITH FOYER SCOPE REMOVED AND NEW SPACE CLASSIFICATION CHANGED

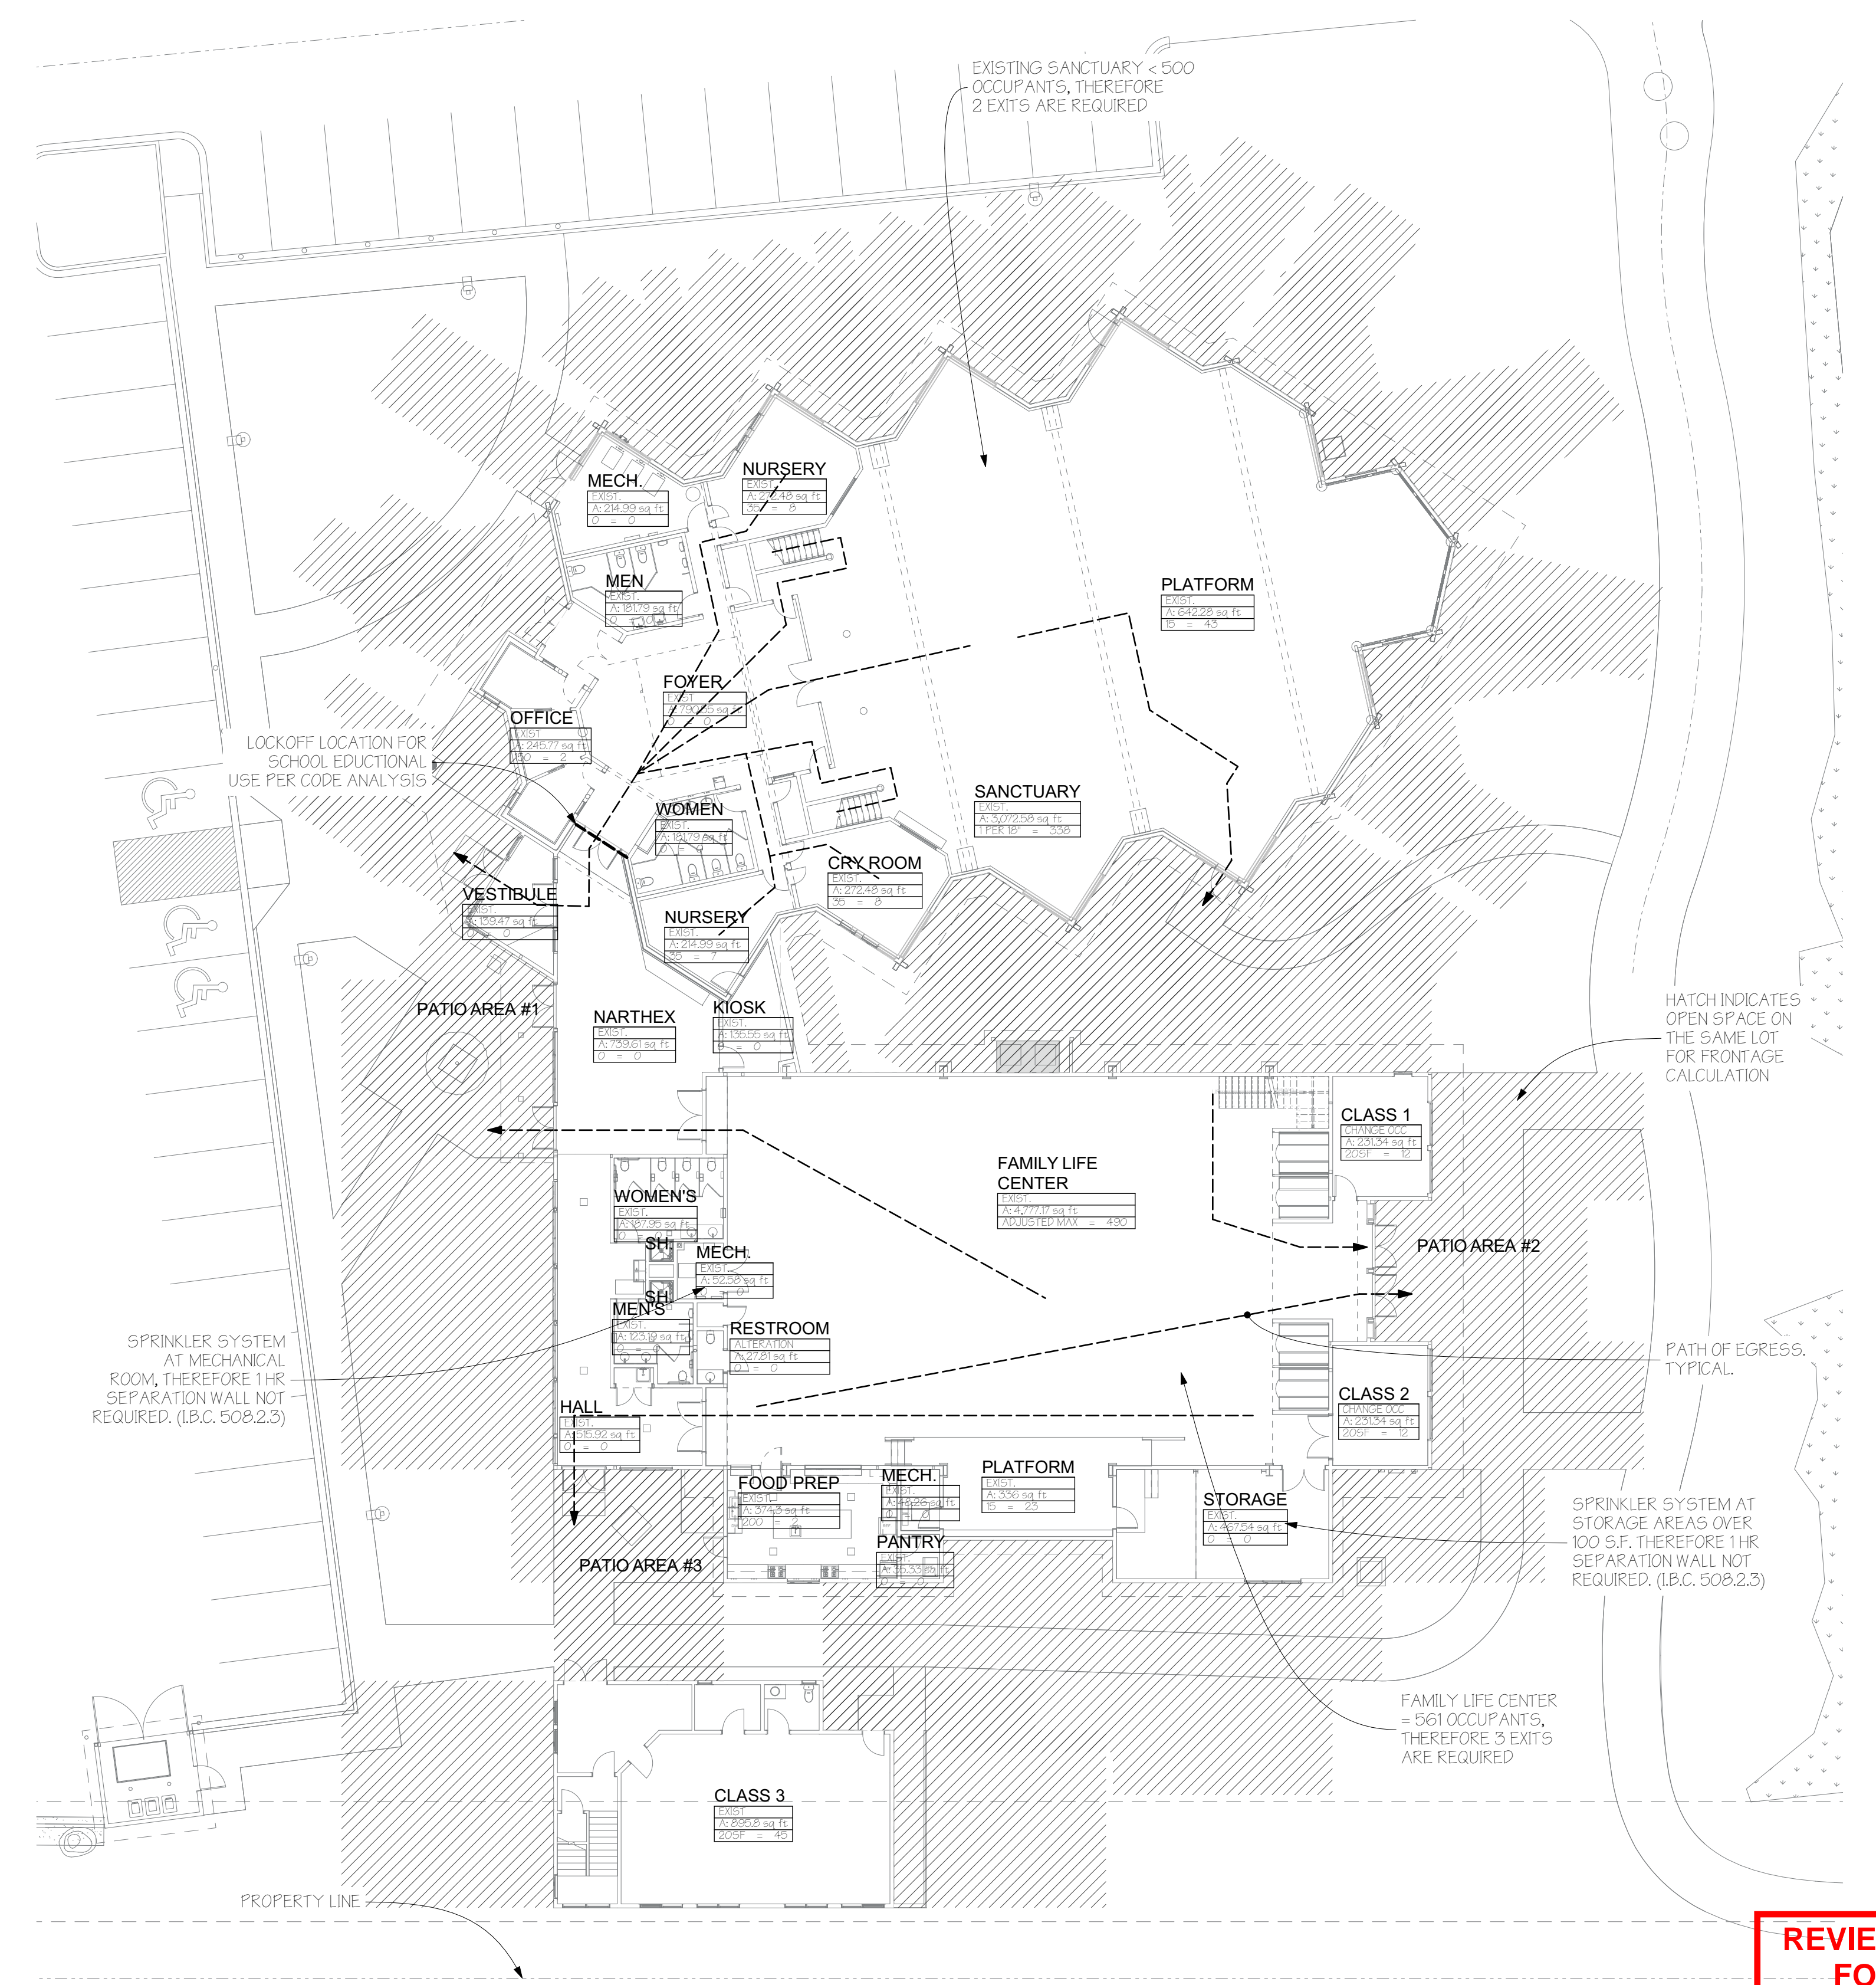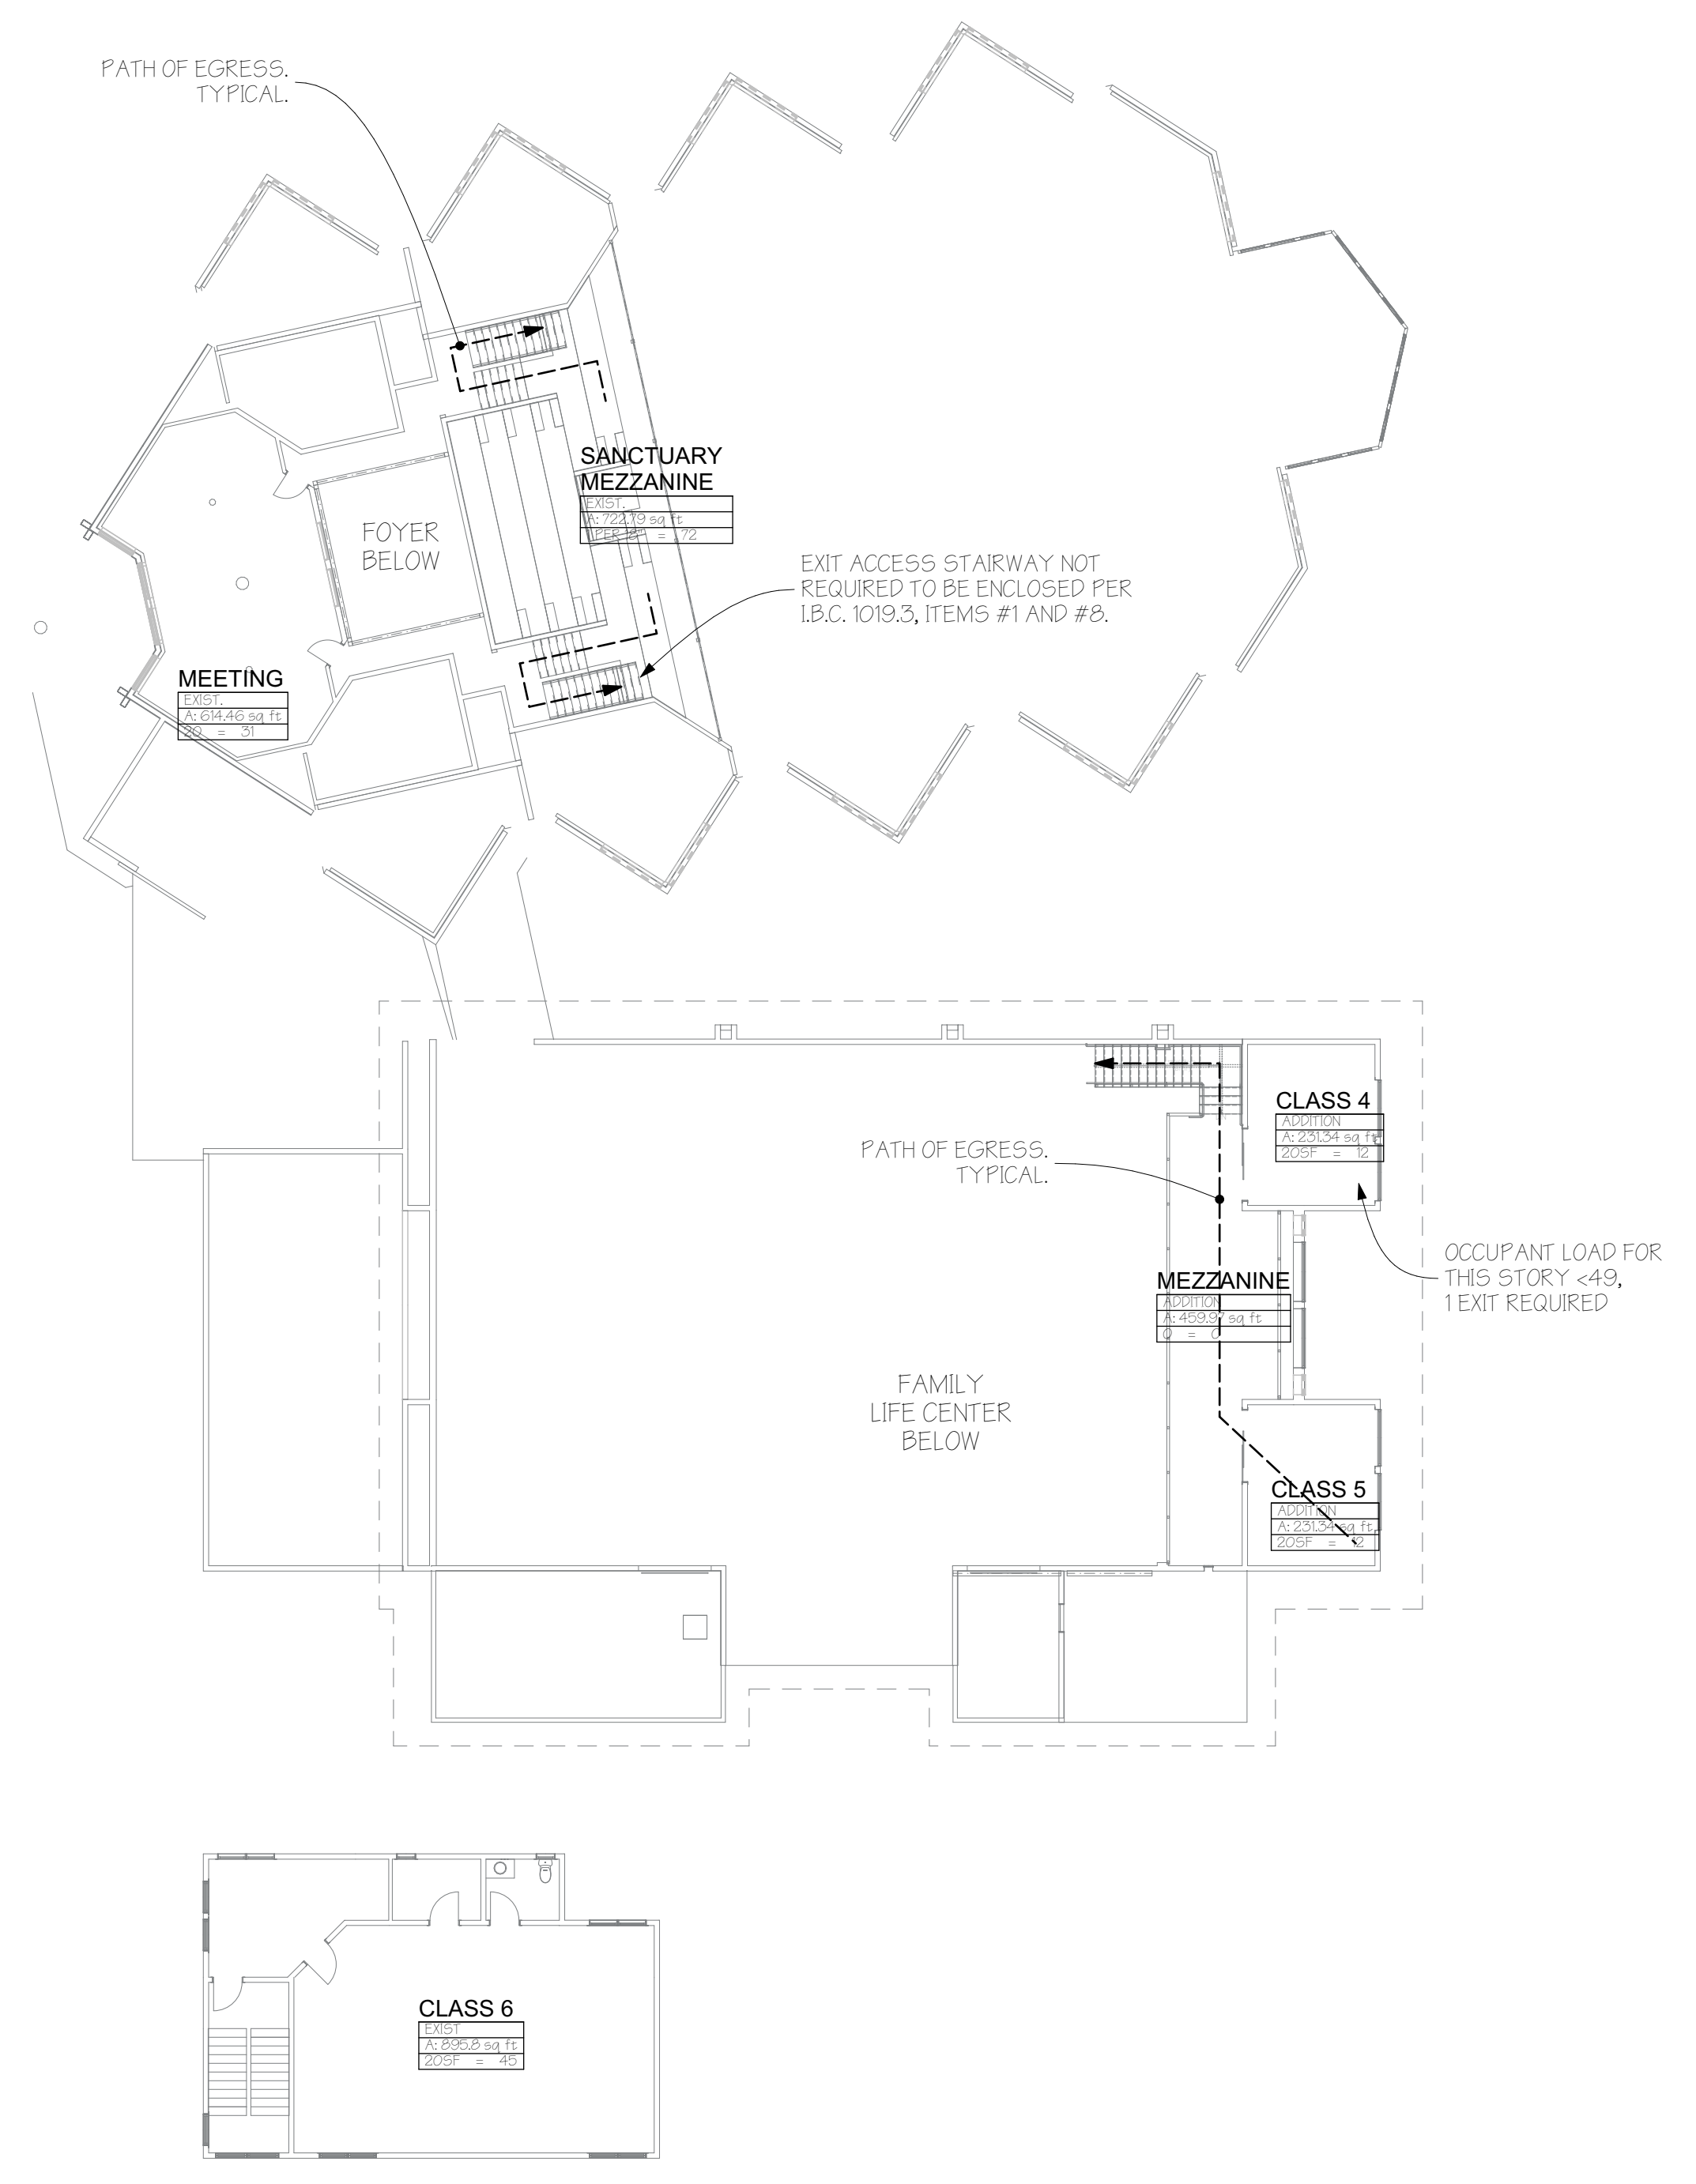


**REVIEWED FOR CODE COMPLIANCE**  
 02/22/2023

SEE SHEET T1.1 FOR ADDITIONAL INFORMATION.  
**CODE ANALYSIS - UPPER LEVEL**  
 SCALE: 1/8" = 1'-0"

SEE SHEET T1.1 FOR ADDITIONAL INFORMATION.  
**CODE ANALYSIS - MAIN LEVEL**  
 SCALE: 1/8" = 1'-0"






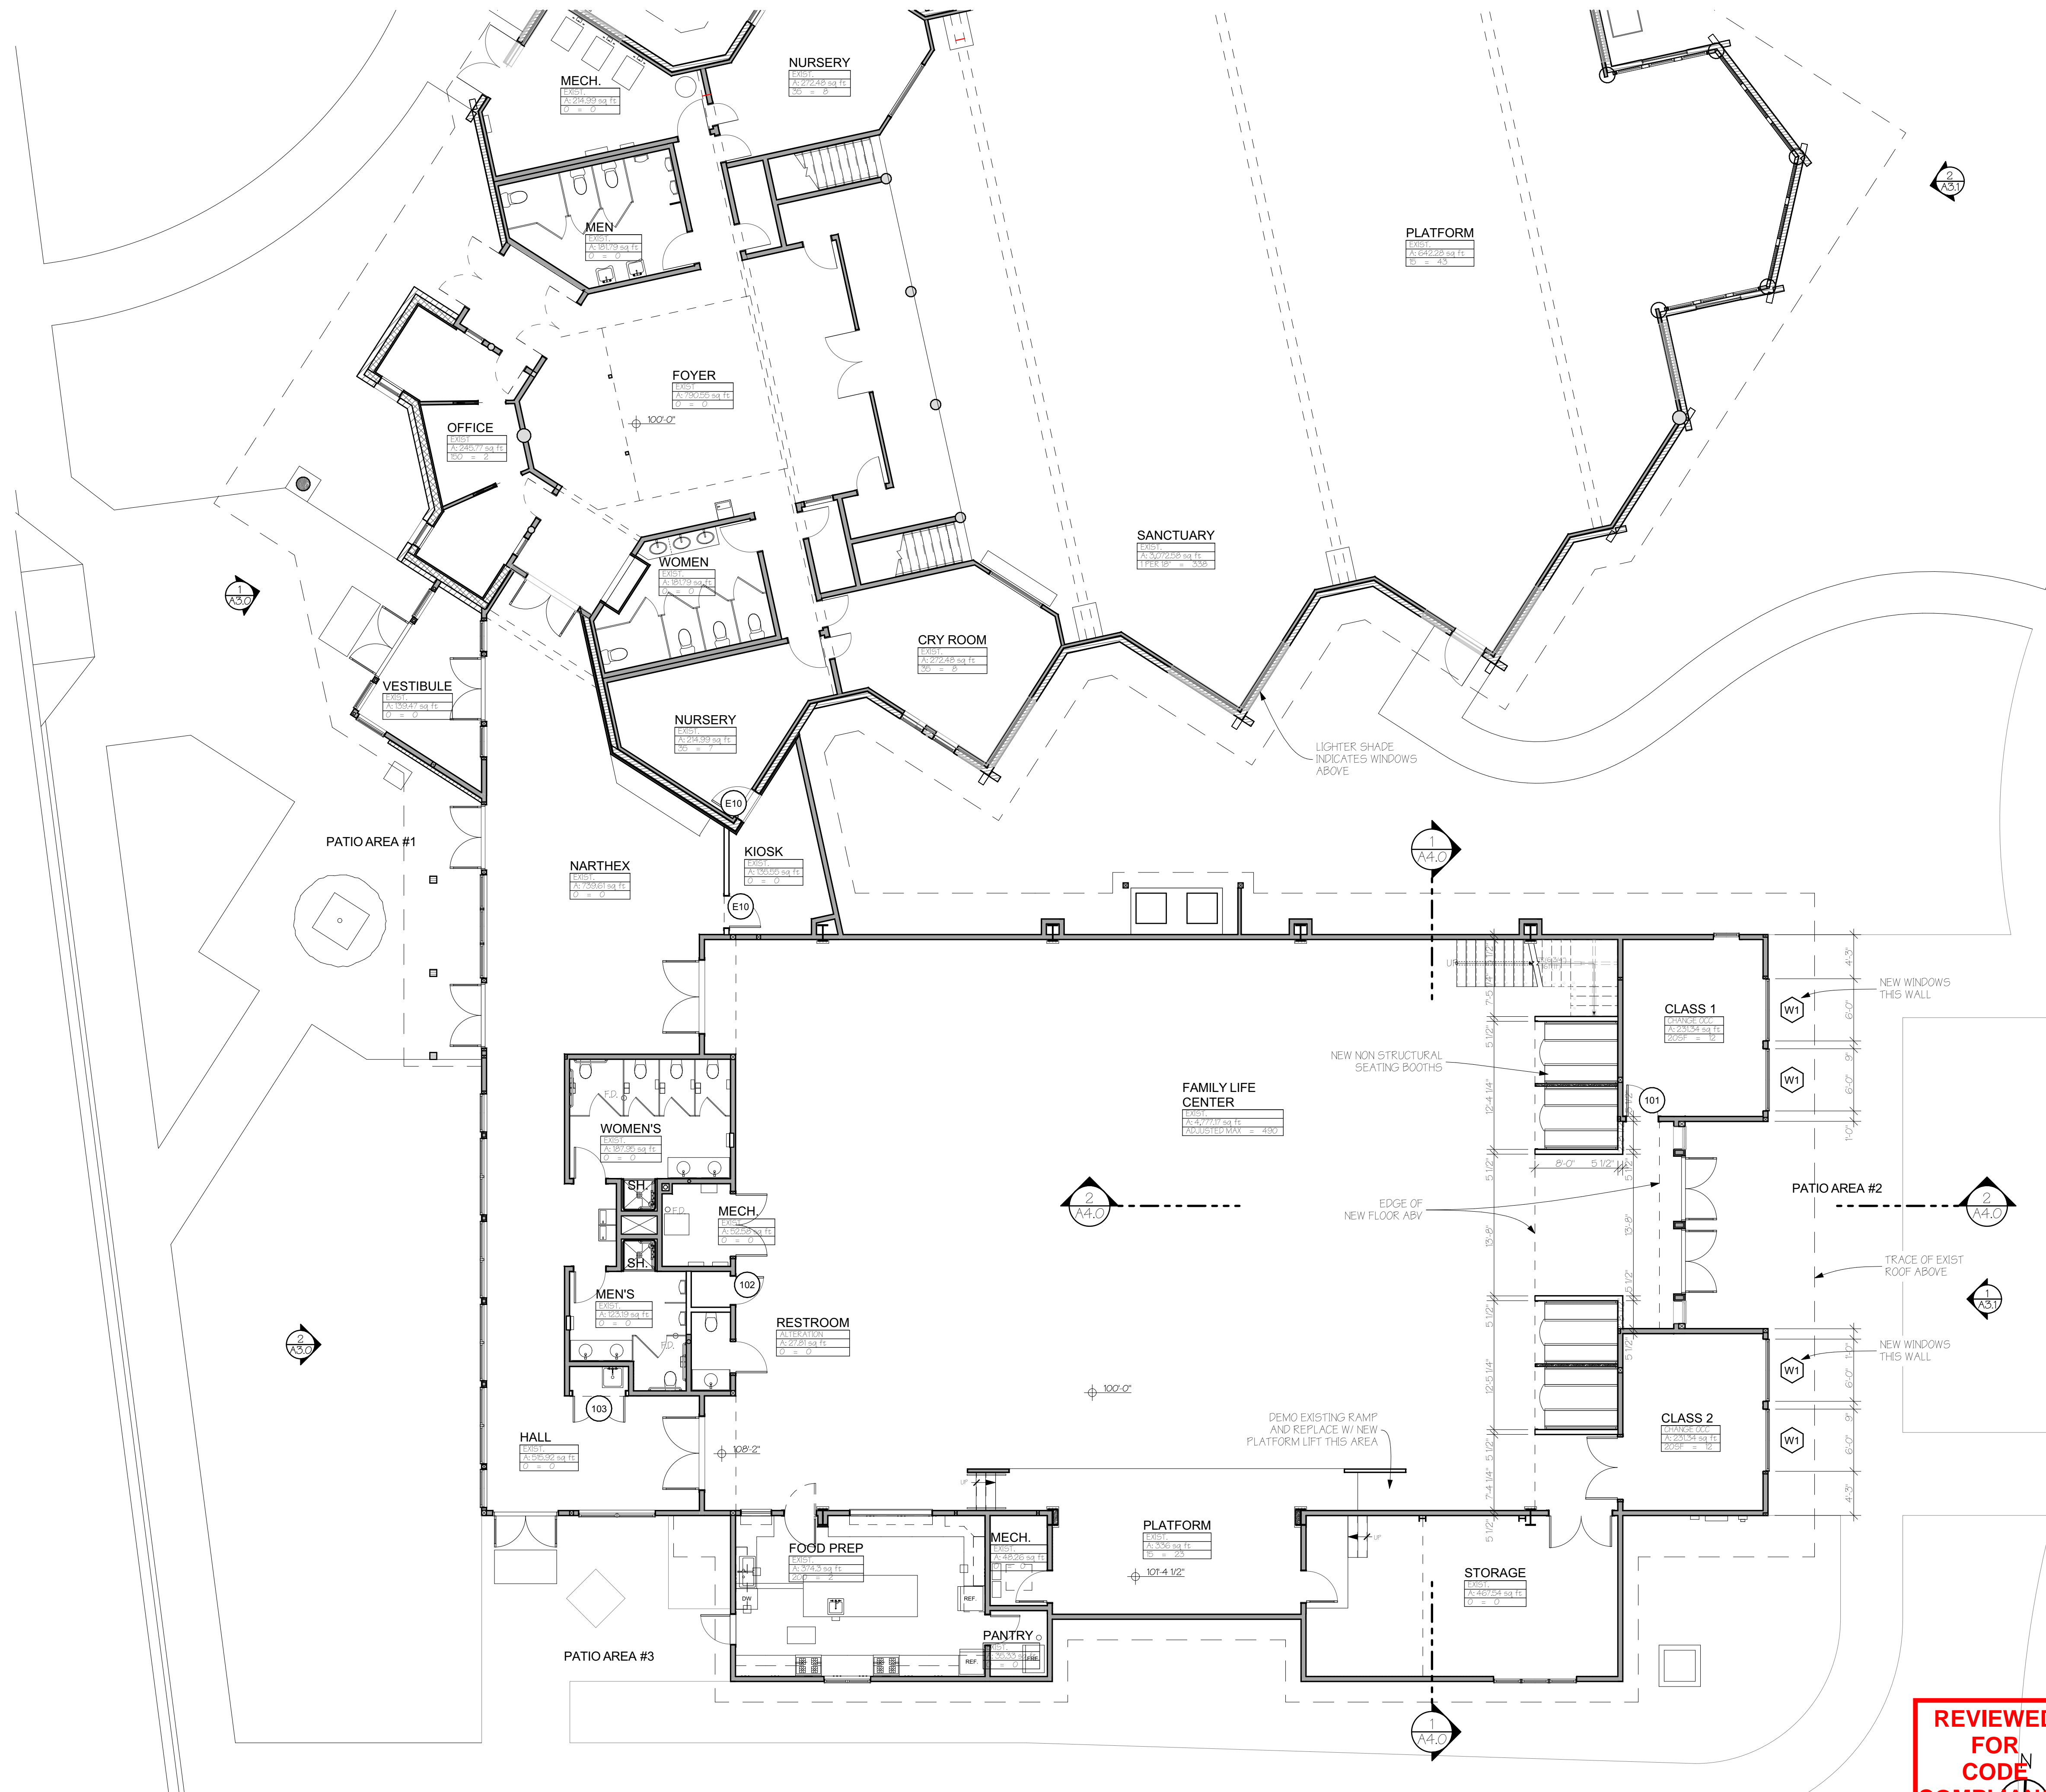

1 MAIN LEVEL PLAN  
SCALE: 1/8" = 1'-0"

**REVIEWED FOR CODE COMPLIANCE**  
02/22/2023

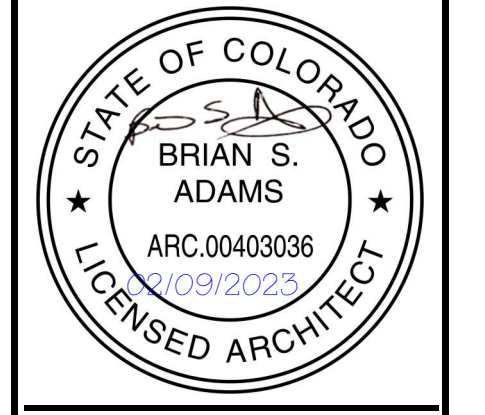

A Remodel for  
**STEAMBOAT CHRISTIAN CENTER**  
 821 DOUGHERTY ROAD  
 TR IN SE4SW4 SEC 28-G-84, TOTAL 5 ACRES  
 STEAMBOAT SPRINGS  
 ROUTT COUNTY, CO

ISSUE	DATE	CHANGE
01	2/9/2023	FOYER

REVISIONS:  
 CURRENT REVISION: 01

ISSUE DATE: 01/11/2023  
 PERMIT


PROJECT NO: 21019

SHEET TITLE:  
 NEW MAIN LEVEL PLAN


SHEET NO:  
**A2.1**  
 Sheet 6 of 13





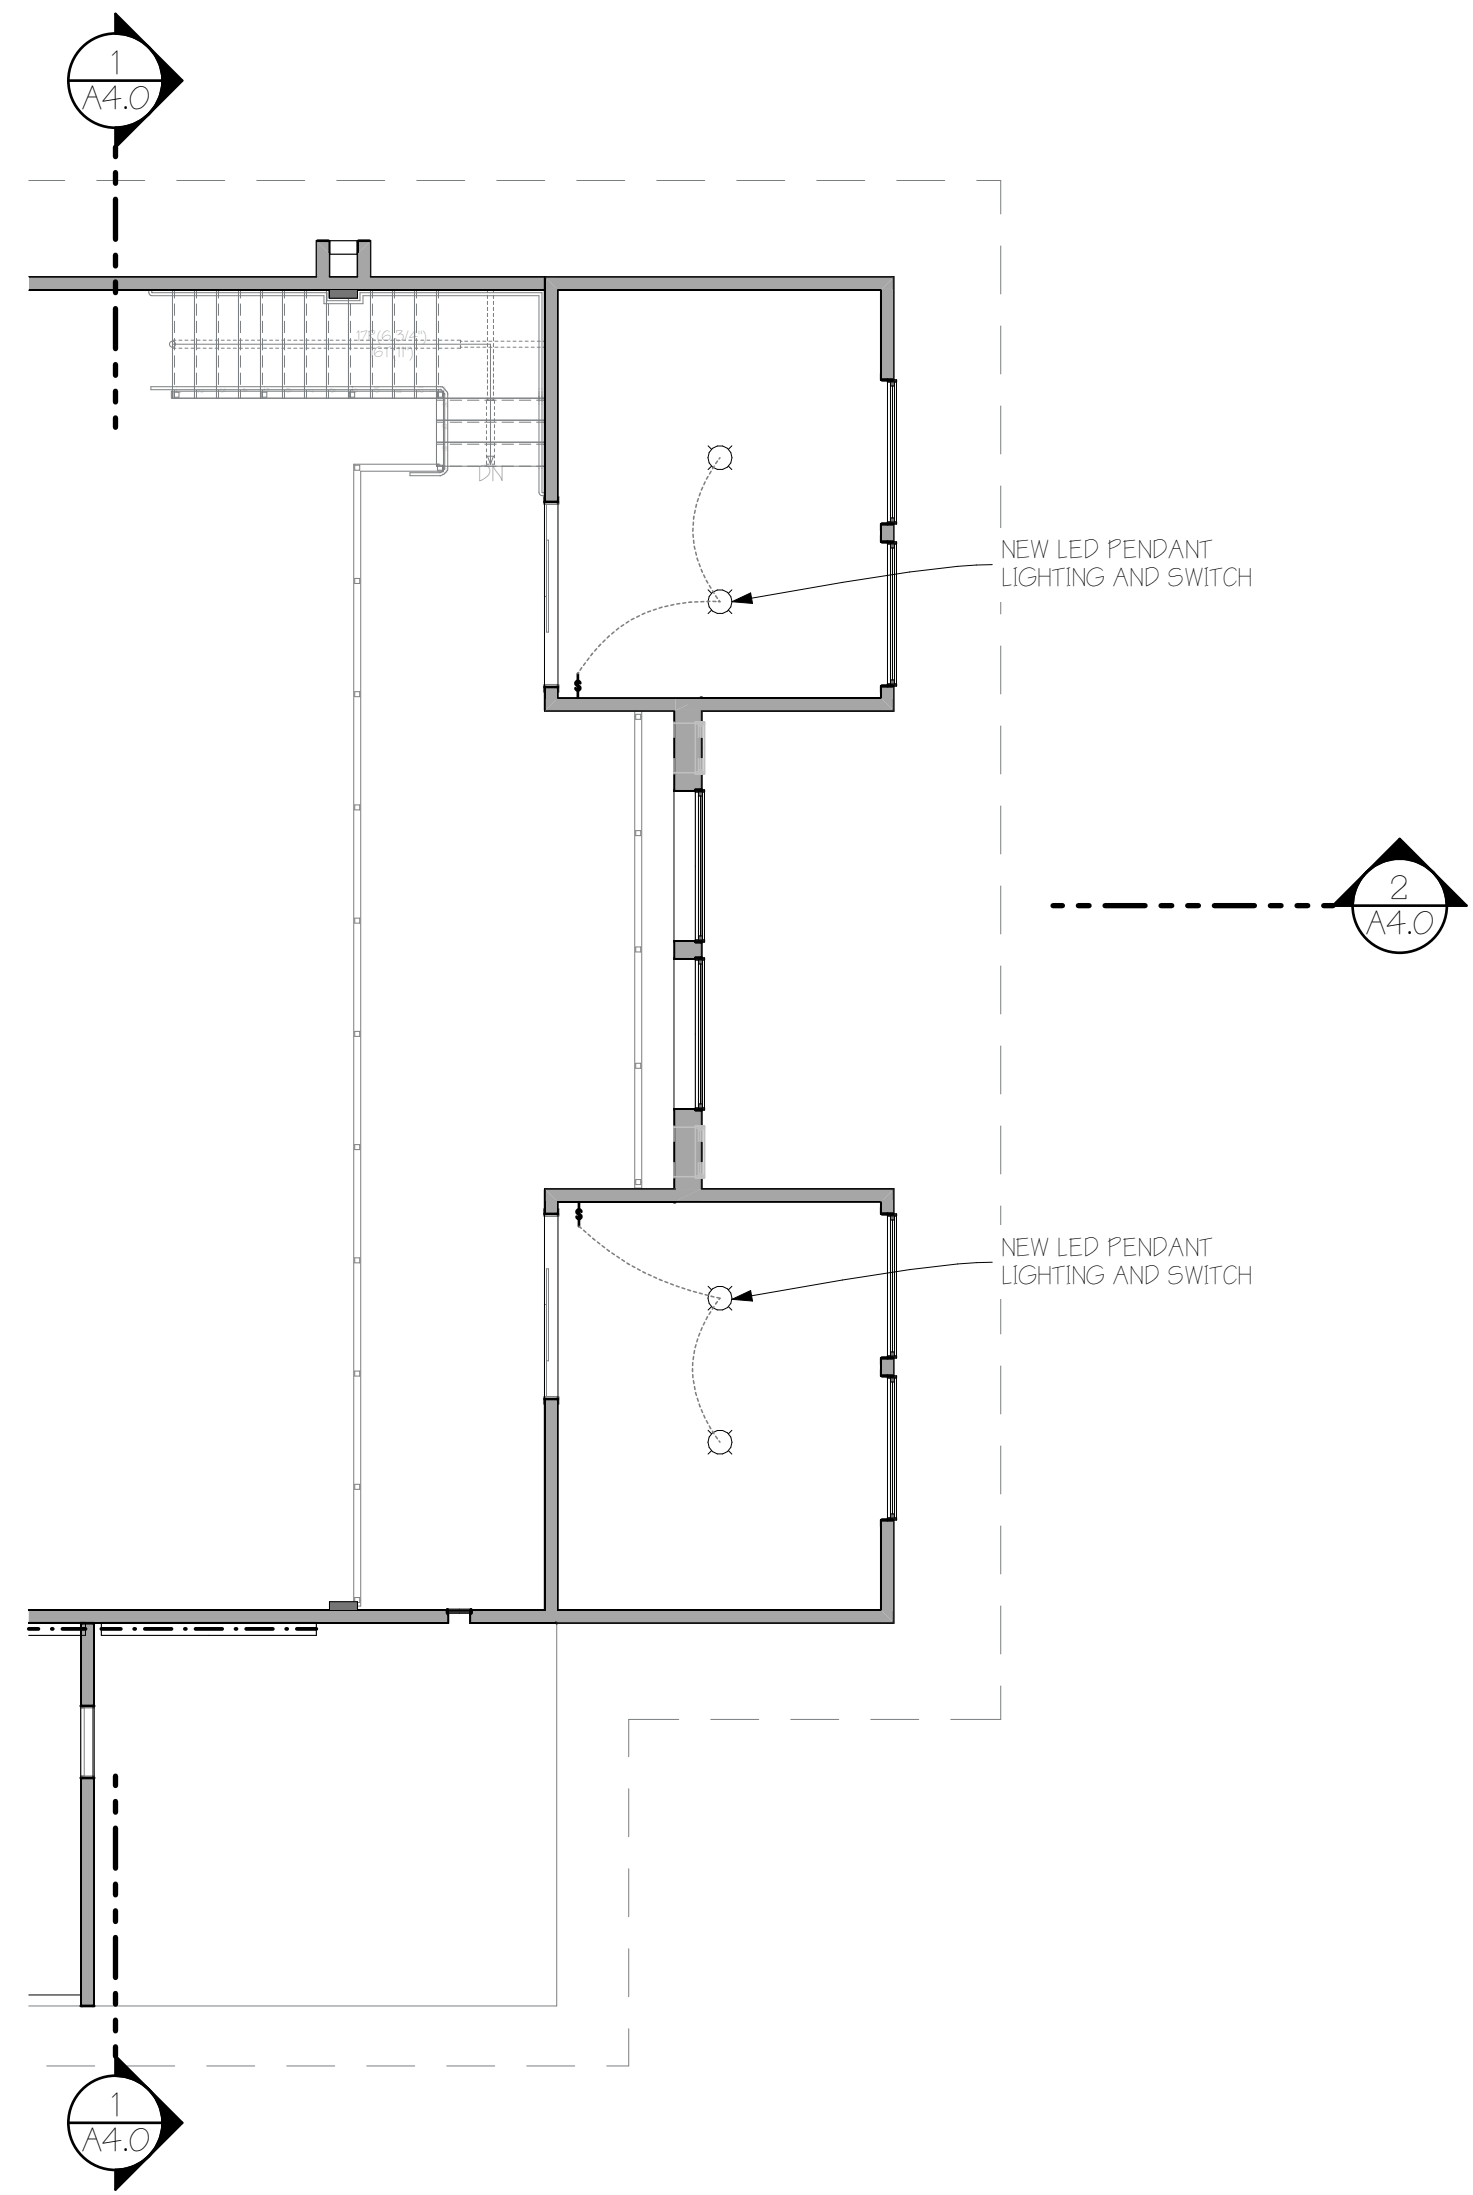


② UPPER LEVEL REFLECTED CEILING PLAN  
SCALE: 1/8" = 1'-0"

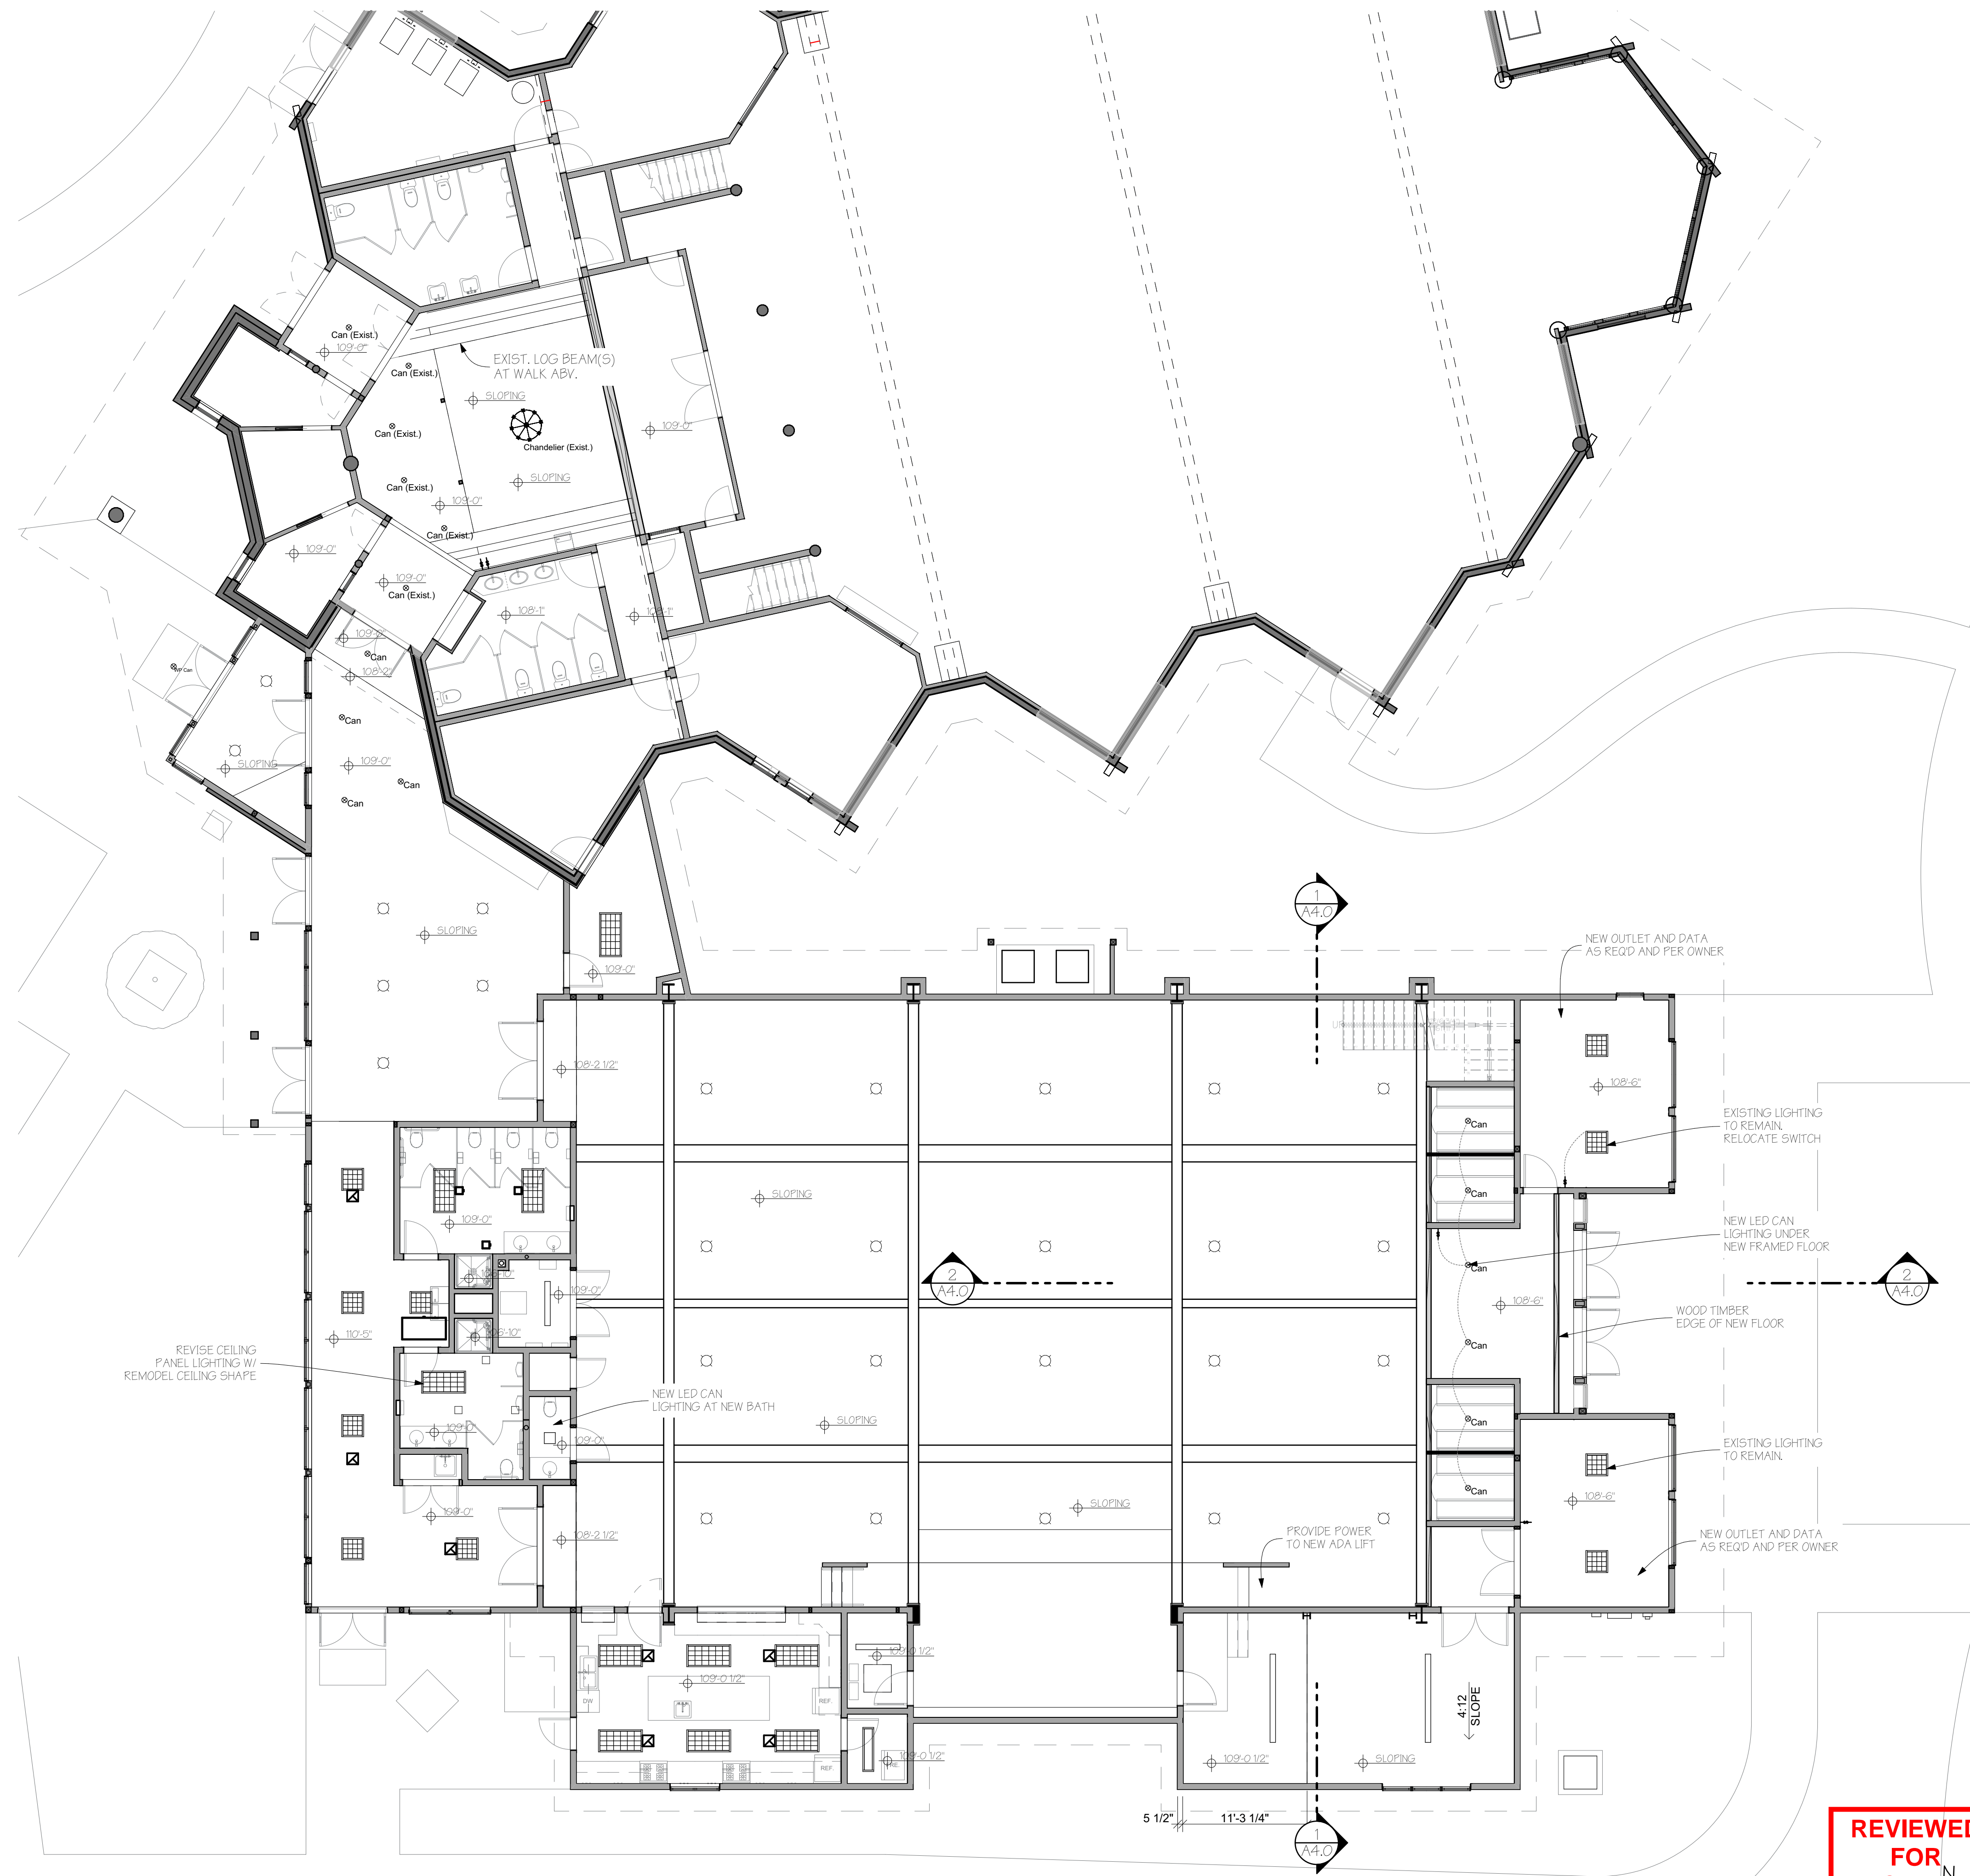

① MAIN LEVEL REFLECTED CEILING PLAN  
SCALE: 1/8" = 1'-0"

**REVIEWED FOR CODE COMPLIANCE**  
02/22/2023

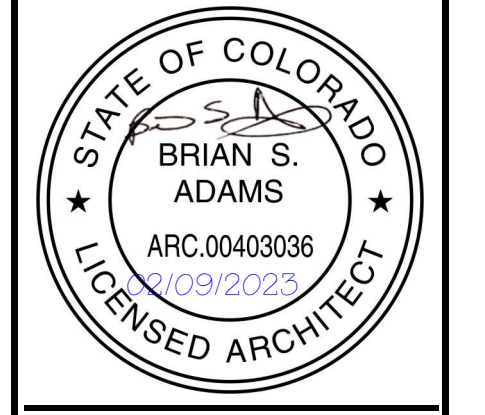


A Remodel for  
**STEAMBOAT CHRISTIAN CENTER**  
 821 DOUGHERTY ROAD  
 TR IN SE4SW4 SEC 28-G-84, TOTAL 5 ACRES  
 STEAMBOAT SPRINGS  
 ROUTT COUNTY, CO


REVISIONS:	
DATE	CHANGE
2/9/2023	FOTER
01	
ISSUE DATE:	01/11/2023 PERMIT
PROJECT NO:	21019
SHEET TITLE:	NEW RCP AND LIGHTING PLAN
SHEET NO:	A2.4





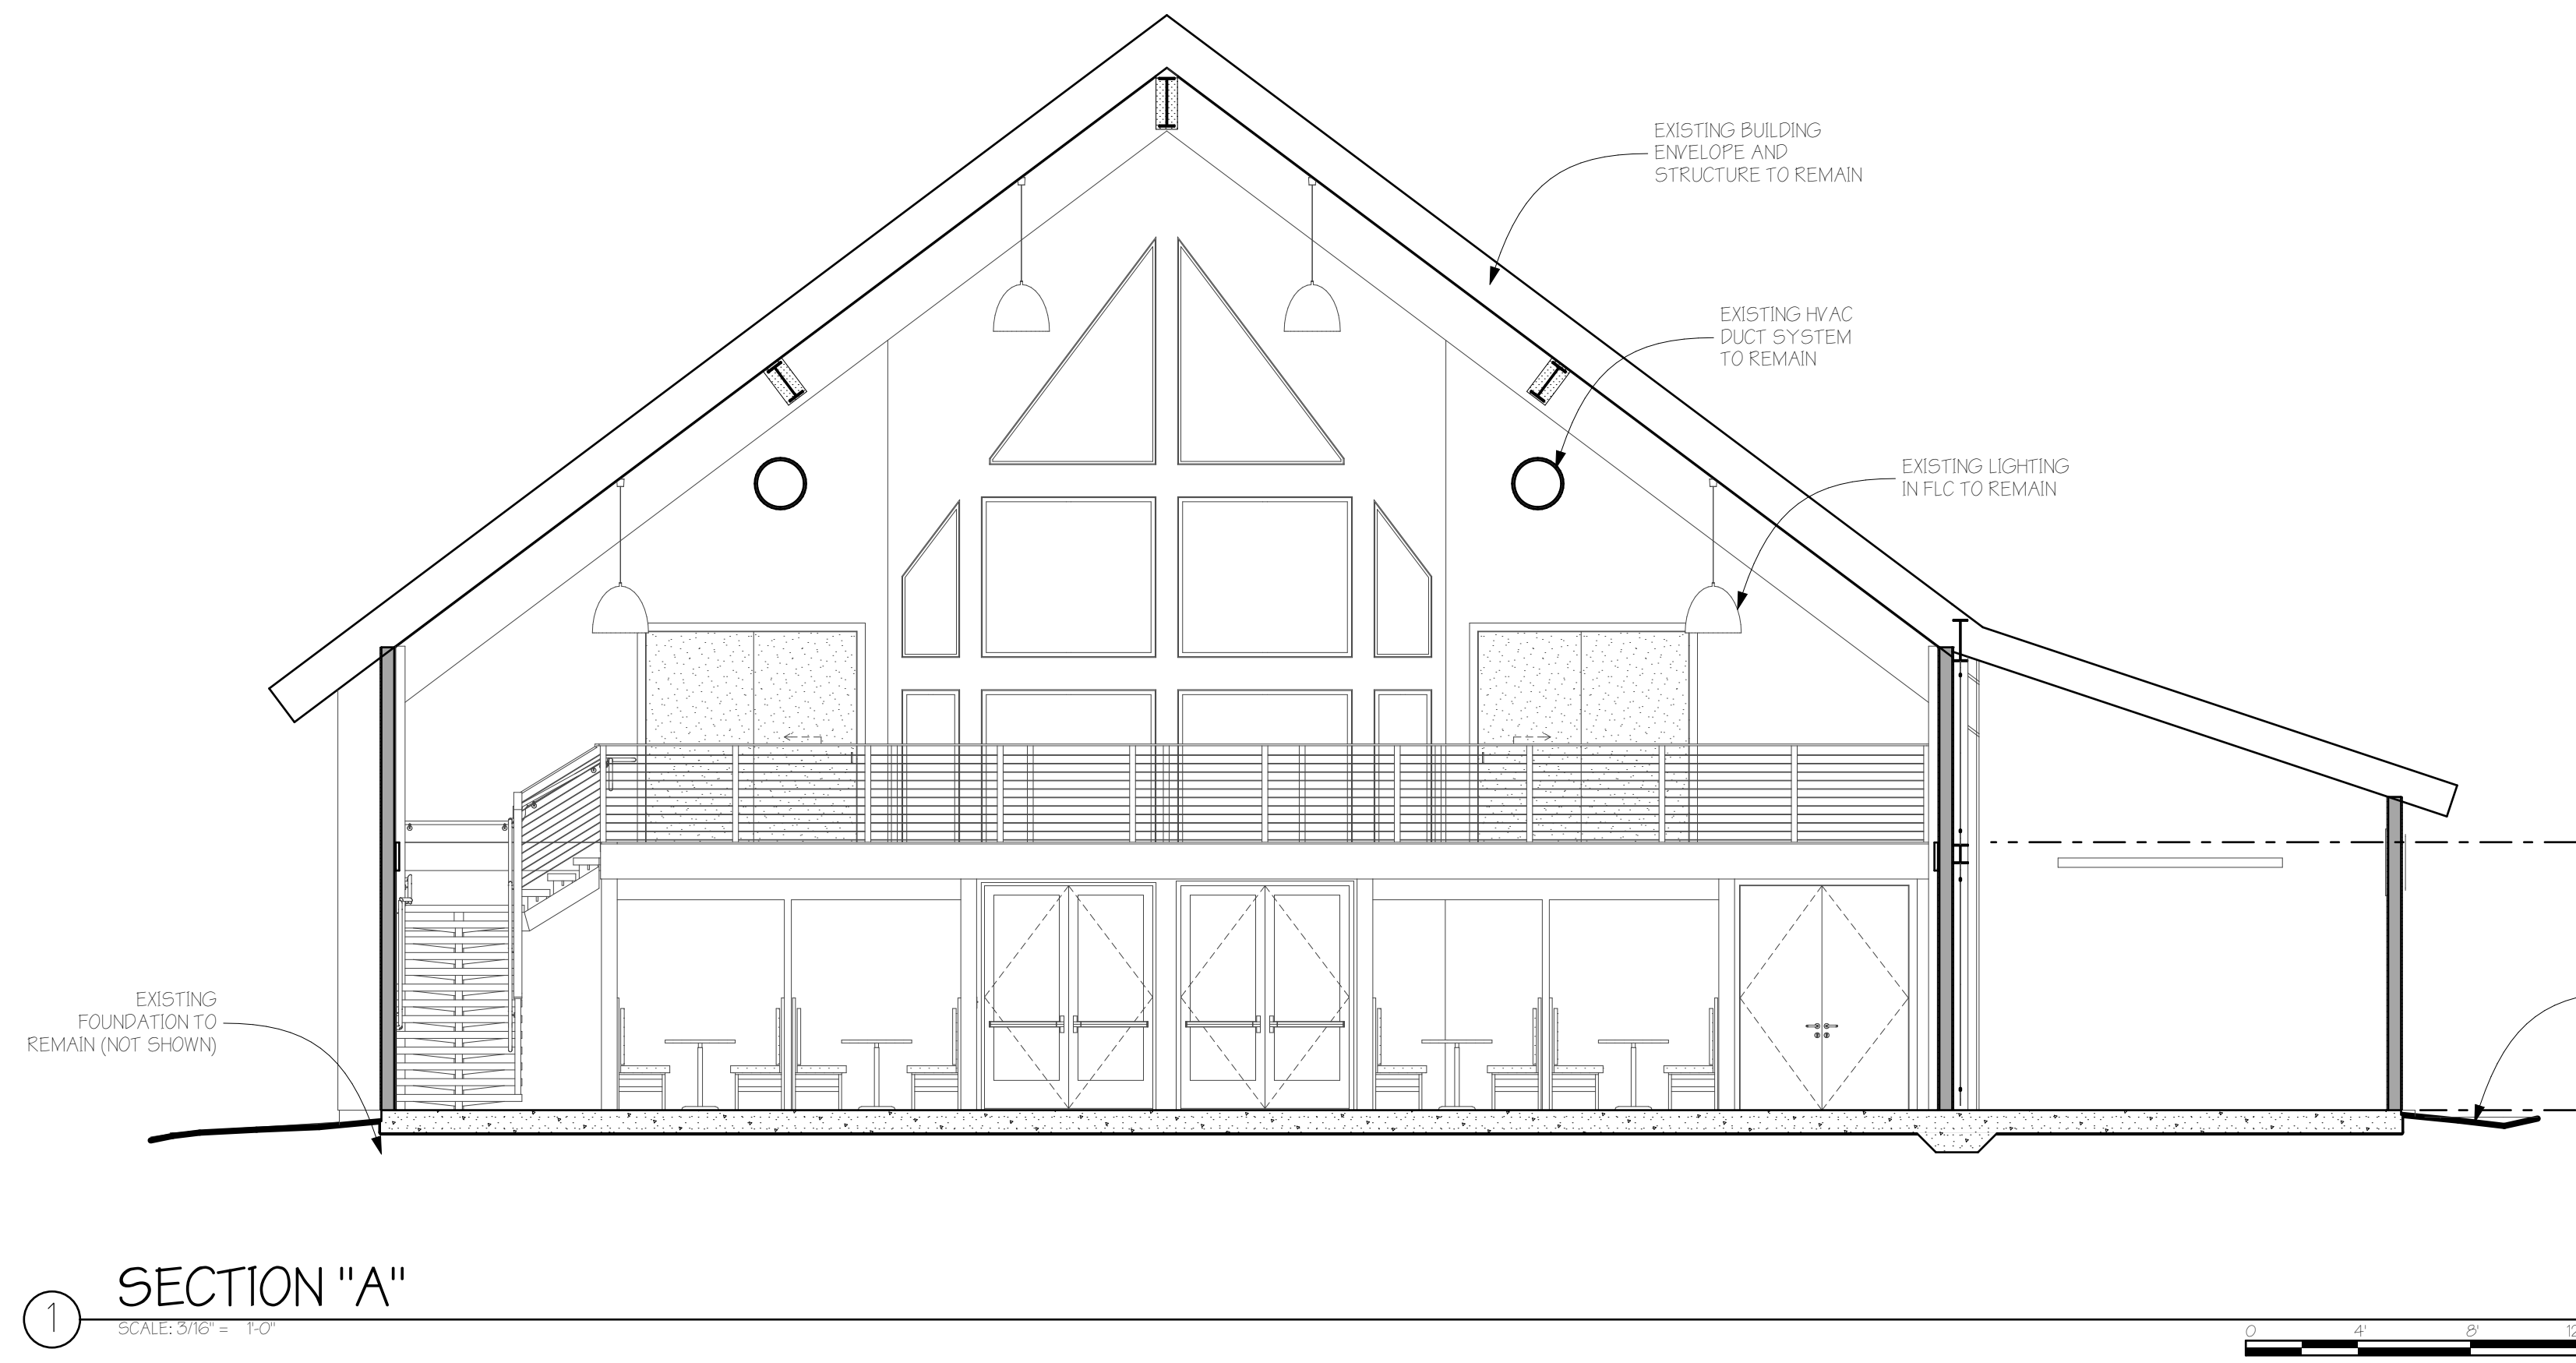

1 SECTION "A"  
SCALE: 3/8" = 1'-0"

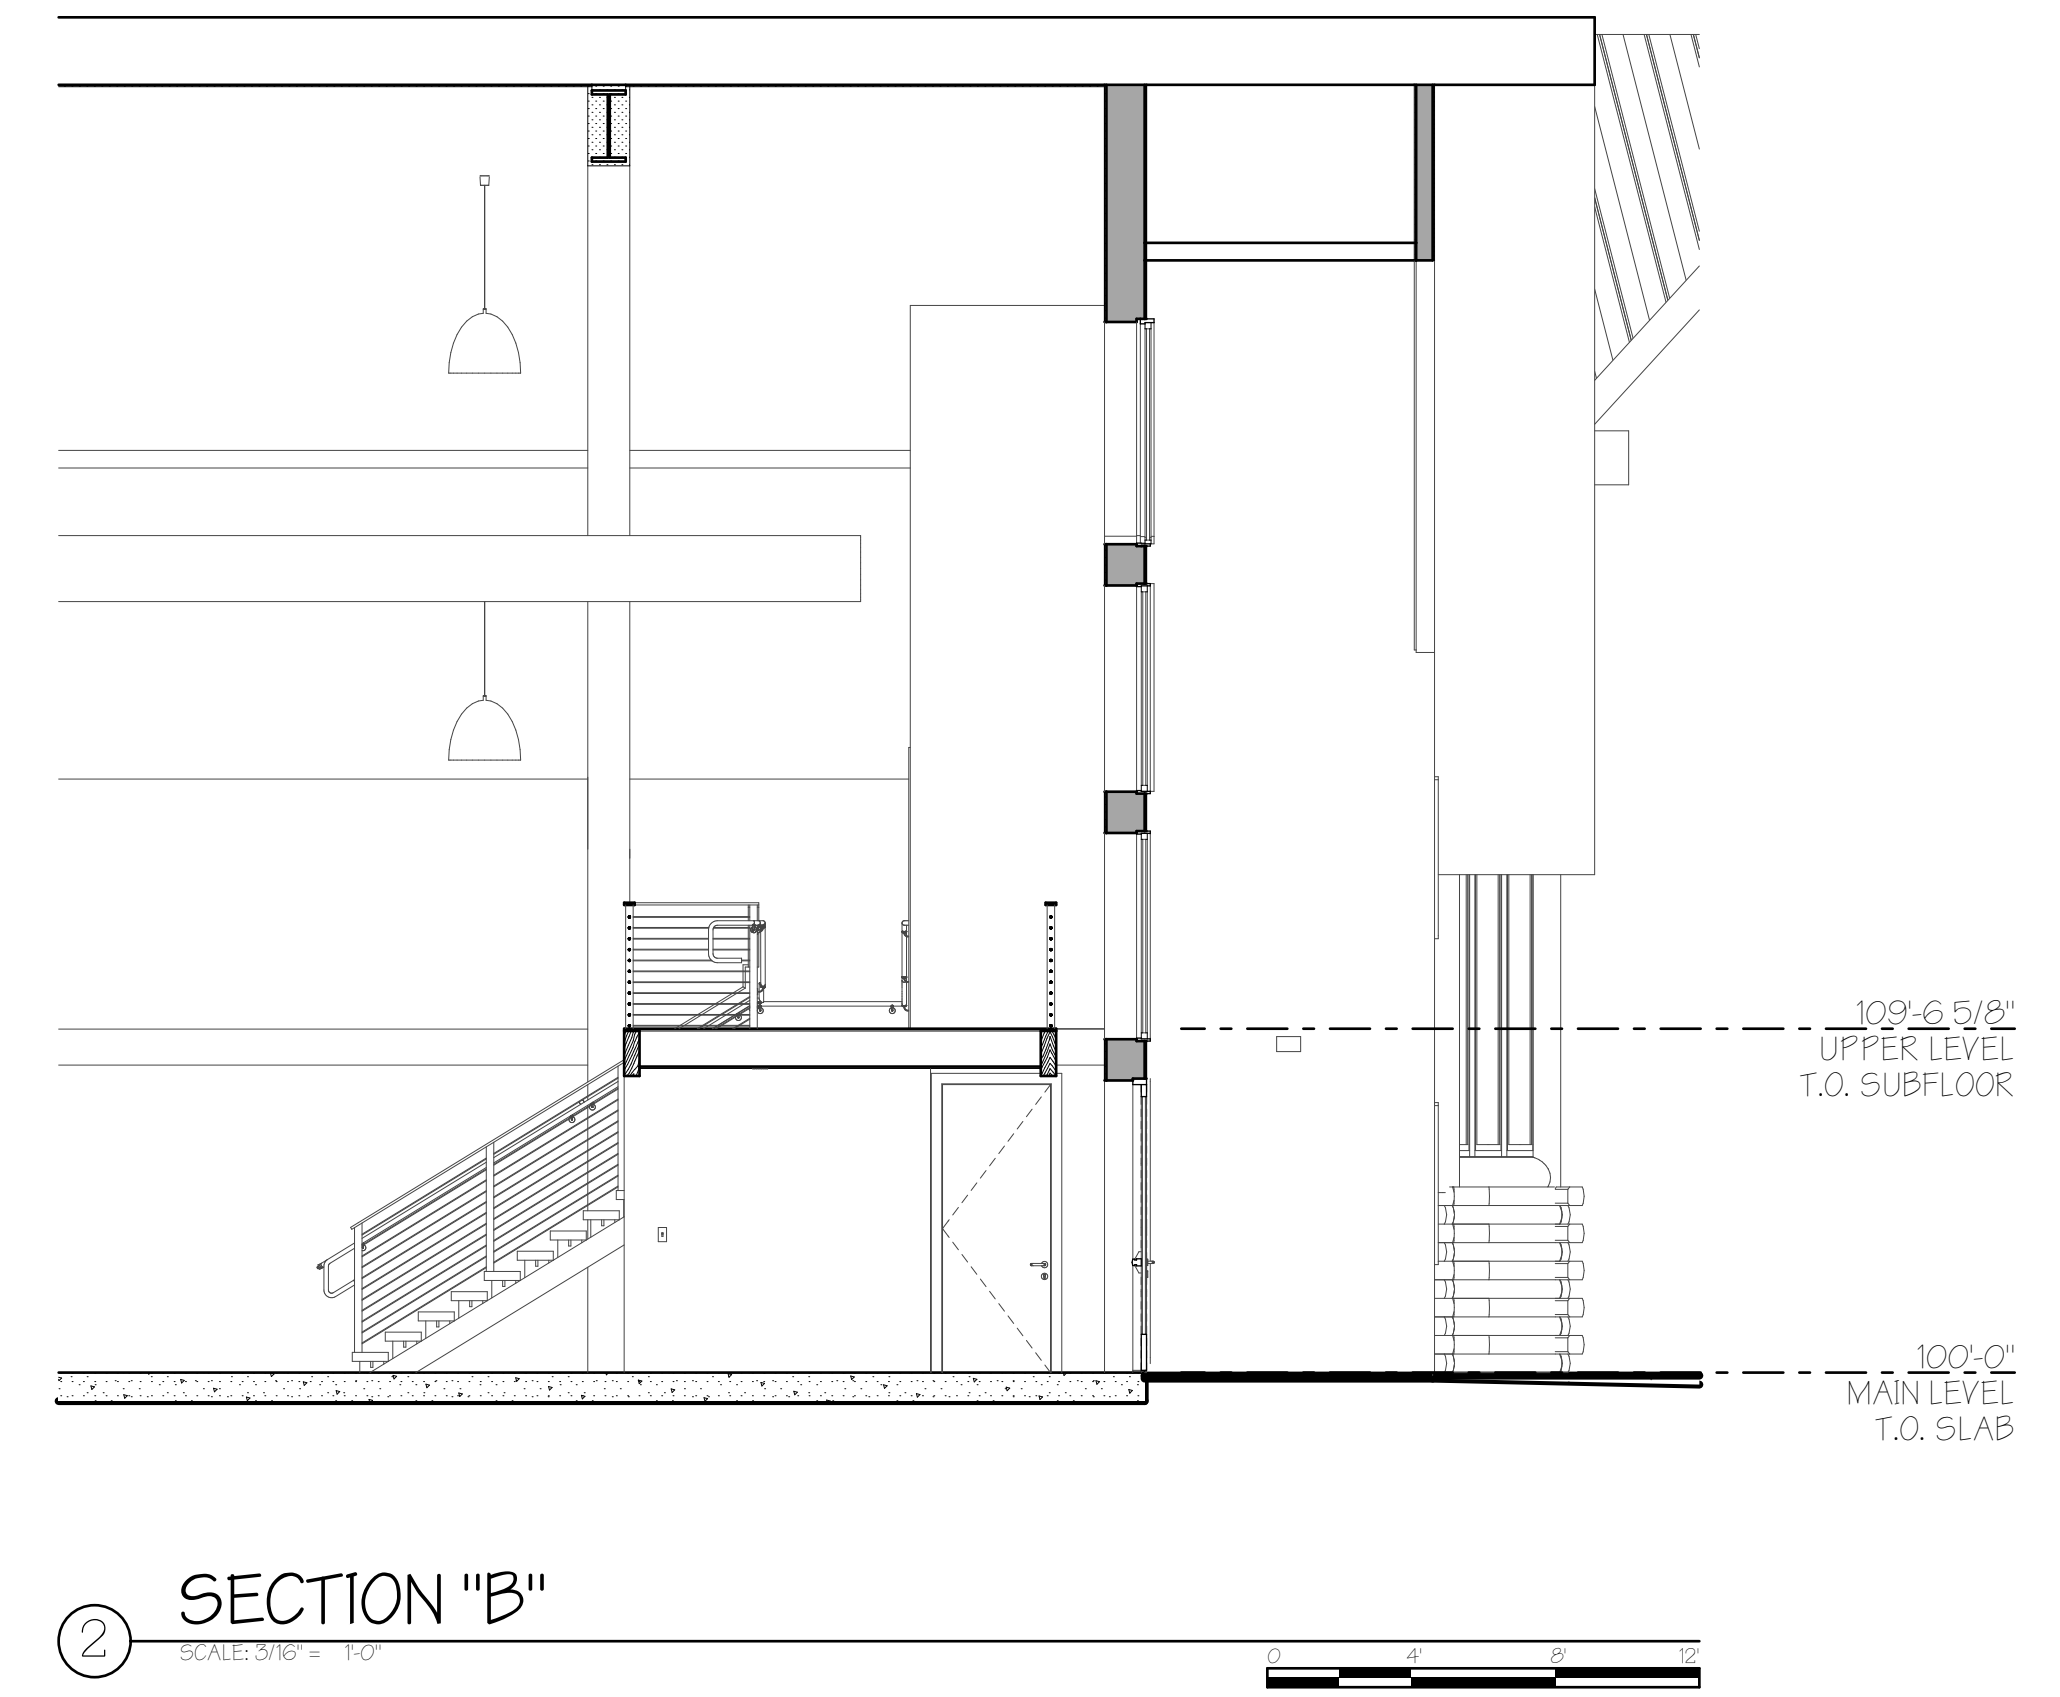

2 SECTION "B"  
SCALE: 3/8" = 1'-0"

ID	SIZE (W X H)	HEAD HEIGHT	QTY	ELEVATION	FUNCTION	NOTES
W1	6'-0" x 4'-6"	7'-6"	4		FIXED	
W2	6'-0" x 4'-6"	7'-0"	4		FIXED	

NOTES:  
1) WINDOW SUPPLIER TO BE SELECTED PRIOR TO R.O. FRAMING. ABOVE SIZES HAVE NOT BEEN VERIFIED WITH A SUPPLIER.  
2) VERIFY EXISTING WALL SYSTEM THICKNESS IN FIELD.


3 WINDOW SCHEDULE

ID	WIDTH	HEIGHT	LOCATION	OPERATION	NOTES
3	8'-0"	8'-0"	NARTHEX		DBL SWING
101	3'-0"	8'-0"	OFFICE		
102	2'-8"	8'-0"	JAN.		VERIFY EXISTING DOOR
103	5'-0"	8'-0"	HALL		
201	7'-6"	7'-6"	CONFERENCE		
NO 202	7'-6"	7'-6"	CONFERENCE		

1) ALL GLASS TO BE TEMPERED GLASS.  
2) SEE DOOR PROFILES THIS SHEET FOR FURTHER INFO.

4 DOOR SCHEDULE

**REVIEWED FOR CODE COMPLIANCE**  
02/22/2023

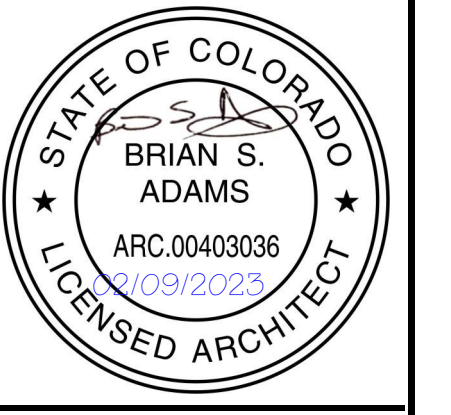

A Remodel for  
**STEAMBOAT CHRISTIAN CENTER**  
821 DOUGHERTY ROAD  
TR IN SE4SW4 SEC 28-6-84, TOTAL 5 ACRES  
STEAMBOAT SPRINGS  
ROUETT COUNTY, CO

REVISIONS:  
CURRENT REVISION: 01

CHANGE	DATE	ISSUE
FOOTER	2/9/2023	01

ISSUE DATE: 01/11/2023  
PERMIT

PROJECT NO: 21019

SHEET TITLE:  
SECTIONS, SCHEDULES

SHEET NO:

A4.0  
Sheet 12 of 13

