
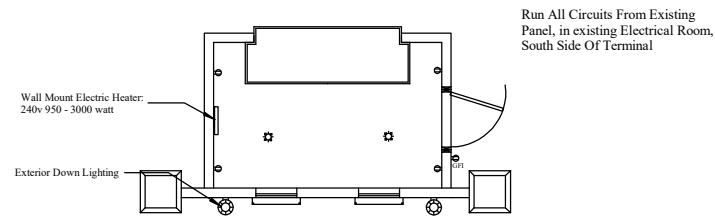


RESOLUTION PLAN

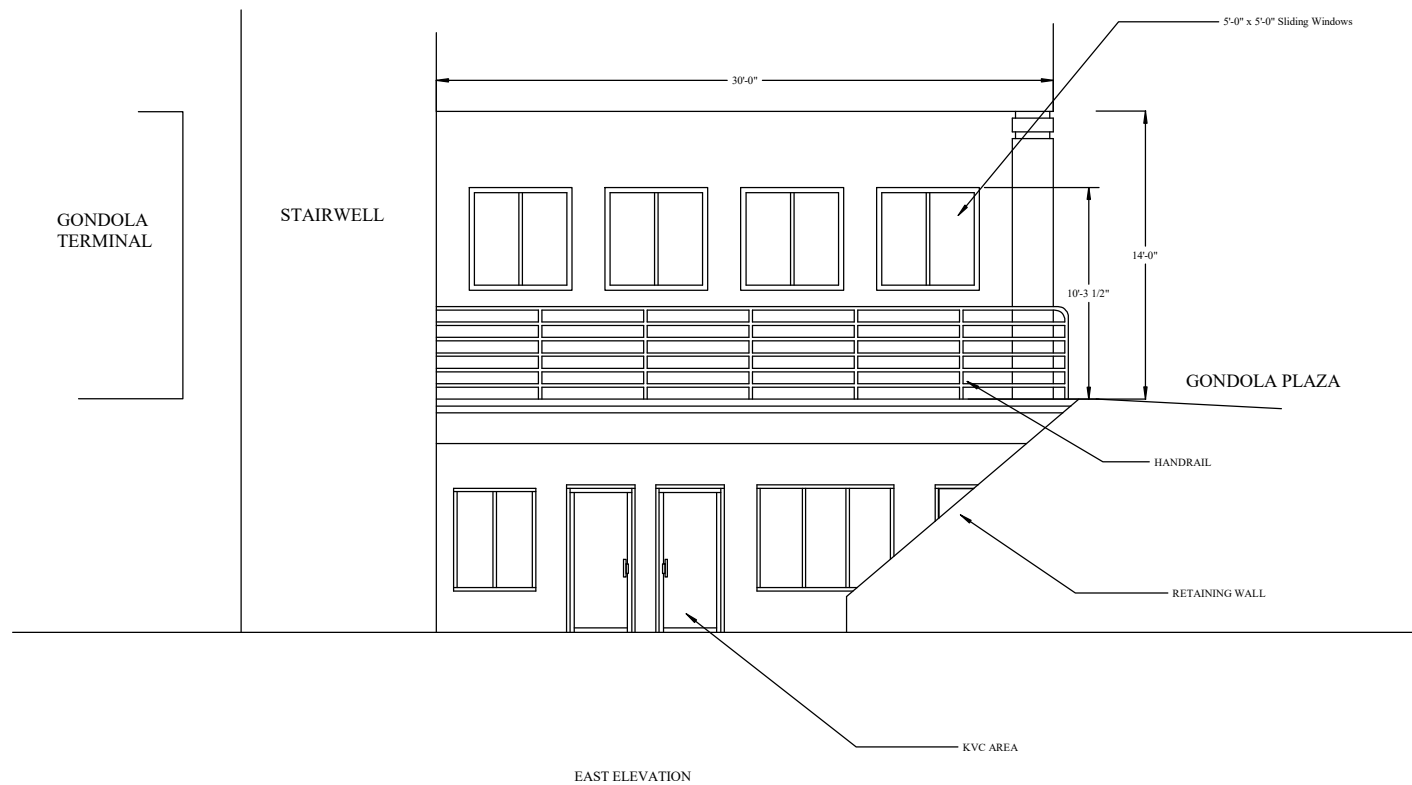

ELECTRICAL PLAN

SHEET: 2 of 3

A-2

TITLE:
GONDOLA CLOSE IN ELEVATIONS

SCALE:
1/4" = 1'

DESIGNED BY:
VTS

TEXT: 1.000
ARROW: 0.700
OTHER: 0.250

DATE:
FEB 2019

FILE:
resolution2A2.tcw

REVISED DATE:
APR 2019