



SITE LIGHTING - PLAZA						
Type	Lamp	Description	Mounting	Manufacturer	Catalog Number	Comments
S1	5903 LUMENS, 55W, 3000K, 80 CRI	SIMILAR TO F1, EXCEPT WALL MOUNTED	WALL	WE-EF	ASP534 LED655-3526	WALL MOUNTED WITH ARM
F1	5903 LUMENS, 55W, 3000K, 80 CRI	TYPE IV MEDIUM BEAM DISTRIBUTION. DIRECT ONLY LED. PROVIDE ALL ARM MOUNTED ON POLE MOUNT ACCESSORIES. WET LOCATION RATED.	POLE MOUNT	WE-EF	ASP534 LED655-3526	POLE MOUNTED FIXTURE, SINGLE HEAD ORIENTED PER PLAN
F2	(2) 5903 LUMENS, (2) 55W, 3000K, 80 CRI	SIMILAR TO F1 EXCEPT DOUBLE POLE MOUNTED FIXTURES 180 DEGREES BACK TO BACK	POLE MOUNT	WE-EF	ASP534 LED655-3526	POLE MOUNTED FIXTURE, DOUBLE HEAD ORIENTED PER PLAN
F8	4080 LUMENS, 48W LED, RGBW	AIMABLE GIMBLE FIXTURE MOUNTED TO POLE WITH WIDE BEAM DISTRIBUTION. PROVIDE FIXTURE WITH GLARE SHIELD AND HONEYCOMB LOUVER.	MOUNTED ON SIDE OF POLE	WE-EF	139-1929 WITH 667-9221	FIXTURE SHALL BE AIMED DOWN AT ICE RINK. FINALIZED AIMING IN FIELD
F8A	4080 LUMENS, 48W LED, RGBW	AIMABLE GIMBLE FIXTURE MOUNTED TO POLE WITH MEDIUM BEAM DISTRIBUTION. PROVIDE FIXTURE WITH GLARE SHIELD AND HONEYCOMB LOUVER.	MOUNTED ON SIDE OF POLE	WE-EF	139-1913 WITH 667-9221	FIXTURE SHALL BE AIMED DOWN AT ICE RINK. FINALIZED AIMING IN FIELD

FIXTURE PLACEMENT LEGEND

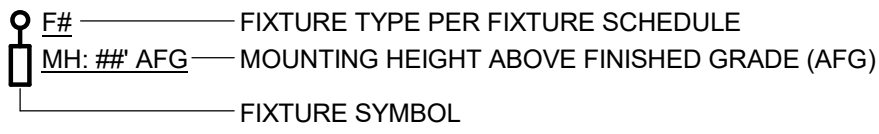

PLAZA LIGHTING - LIGHT FIXTURE SCHEDULE

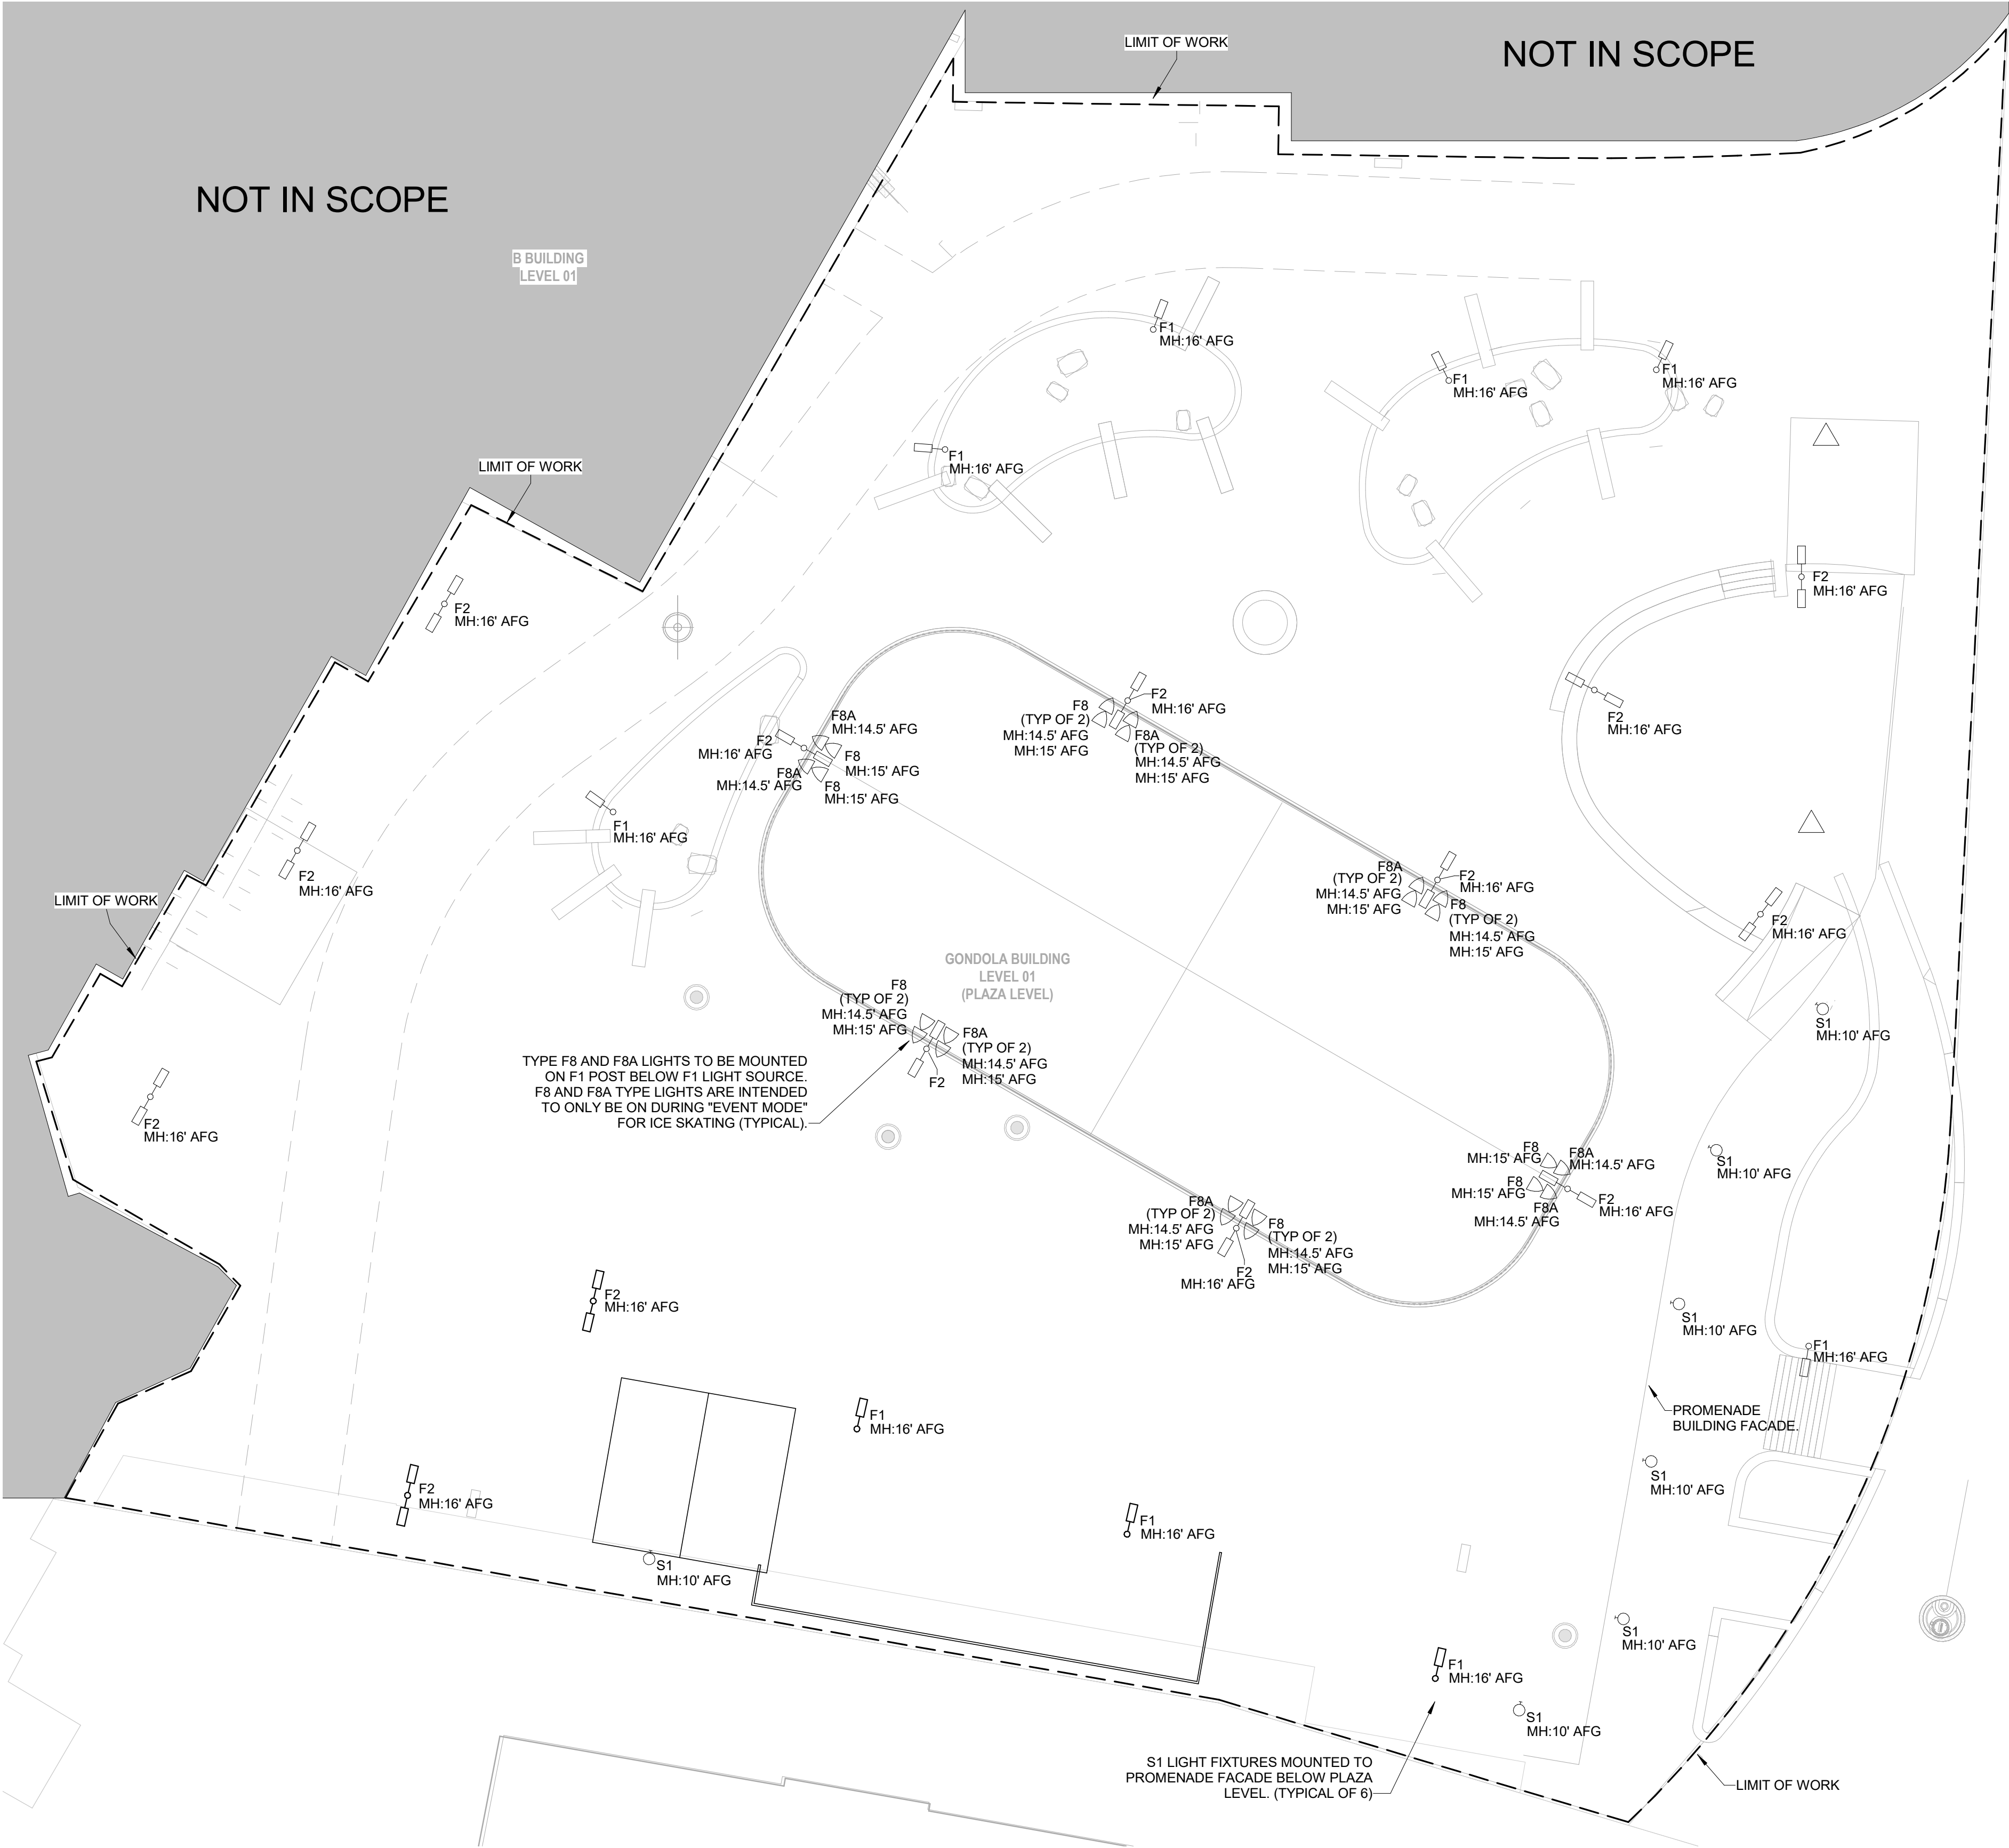

1 SITE PLAN PLAZA
SCALE: 1/16" = 1'-0"

2305 Mount Werner Circle
Steamboat Springs, CO 80487

Gensler

1225 17th Street
Suite 150
Denver, CO 80202
United States
Tel 303.595.8585
Fax 303.825.6823



141 9th Street
PO Box 774943
Steamboat Springs, CO
80477
Tel 970.871.9494

DESIGNWORKSHOP

1390 Lawrence Street
Suite 100
Denver, CO 80204
Tel 303.623.5186



14143 Denver West Pkwy
Suite 300
Golden, CO
United States
Tel 303.421.6655

Date	Description
2021/02/10	DEVELOPMENT PACKAGE SUBMITTAL
2021/04/07	DEVELOPMENT PACKAGE RESUBMITTAL 01
1 2021.07.13	BP3:PROMENADE - BULLETIN 04

Seal / Signature

NOT FOR
CONSTRUCTION

Project Name	SSRC - Base Area Plaza Improvements
Project Number	003.7835.000
Description	SITE LIGHTING PLAN - PLAZA

Scale
NOT TO SCALE

E.001