

ELECTRICAL EQUIPMENT CONNECTION SCHEDULE												
GENERAL NOTES: 1. THIS SCHEDULE IS FOR ELECTRICAL EQUIPMENT CONNECTIONS ONLY. EQUIPMENT BY OTHERS. 2. PROVIDE A DEDICATED CIRCUIT WITH A DEDICATED NEAUTRAL FOR ALL EQUIPMENT UNLESS OTHERWISE NOTED. 3. CONFIRM ALL EQUIPMENT LOCATIONS AND ELEVATIONS PRIOR TO ROUGH-IN. 4. CONFIRM ALL EQUIPMENT FEEDER, DISCONNECT AND FUSING WITH SUBMITTED/PURCHASED EQUIPMENT PRIOR TO ROUGH-IN.						REMARK NOTES: A. PROVIDE GFCI CIRCUIT BREAKER. B. COORDINATE LOCATION OF ELECTRICAL RECEPTACLE WITH FOUNTAIN ROUGH IN DRAWING RECOMMENDATIONS.						
EQ #	EQUIPMENT DESCRIPTION	HP	LOAD (VA)	VOLTAGE	PHASE	FLA	DISCONNECT	FUSE	FEEDER	CONDUIT	REMARKS	
2	GARBAGE DISPOSAL	-	1440	120 V	1	12 A	-	-	2 #12 & #12 GND	3/4"		
3	COPIER	-	1560	120 V	1	13 A	-	-	2 #12 & #12 GND	3/4"		
4	DISHWASHER	-	1560	120 V	1	13 A	-	-	2 #12 & #12 GND	3/4"		
5	DRINKING FOUNTAIN	-	600	120 V	1	5 A	-	-	2 #12 & #12 GND	3/4"	A, B	
6	MICROWAVE	-	1560	120 V	1	13 A	-	-	2 #12 & #12 GND	3/4"		
7	REFRIGERATOR	-	720	120 V	1	6 A	-	-	2 #12 & #12 GND	3/4"		
9	UNDERCOUNTER REFRIGERATOR	-	360	120 V	1	3 A	-	-	2 #12 & #12 GND	3/4"		
12	SKI BOOT DRYER (DOUBLE CONNECTION)	-	156	120 V	1	1 A	-	-	2 #12 & #12 GND	3/4"		
12A	SKI BOOT DRYER - WALL CONNECTION	-	156	120 V	1	1 A	-	-	2 #12 & #12 GND	3/4"		
13	GAS COMMERCIAL DRYER	-	1440	120 V	1	12 A	30A/1P	-	2#12 & #12 GND	3/4"		
14	COMMERCIAL WASHER	-	3328	208 V	1	16 A	-	-	3 #12 & #12 GND	3/4"		
14A	RESIDENTIAL STYLE WASHER	-	1800	120 V	1	15 A	-	-	2#12 & #12 GND	3/4"		
15	COFFEE MAKER	-	1920	120 V	1	16 A	-	-	2 #12 & #12 GND	3/4"		
16	ICE/WATER DISPENSER	-	1440	120 V	1	12 A	-	-	2 #12 & #12 GND	3/4"		

LIGHT FIXTURE SCHEDULE

	L1	Lamp 42W LED, 3000 LUMENS PER 4 FEET OF FIXTURE, 3500K, 80+ CRI, 50,000+ HOURS	Description LED STRIPLIGHT WITH DIFFUSE LENS, PROVIDE SURFACE OR PENDANT MOUNT SUPPORTS PER MOUNTING HEIGHT	Finish WHITE	Voltage 120/277	Mounting PENDANT TO 10 FT. AFF	Manufacturer LITHONIA	Catalog Number CLX-L48-3000LM- SEF-FDL	Alternate 1 COOPER METALLUX SNLED SERIES	Alternate 2 DAYBRITE FSS LED SERIES	Control ON/OFF	Location MEP, STORAGE	Comments PROVIDE ADDITIONAL QUANTITY OF COMPLETE LIGHT FIXTURE, WITH A QTY OF 0.25% OF TOTAL QTY AND A MIN. QTY OF 2 FIXTURES.
	L2	15 WATT LED, 600 LUMENS, 4000K,	WALL MOUNTED LED 'JELLY JAR' STYLE LIGHT FIXTURE WITH METAL GUARDING AROUND FIXTURE LENSING (LIGHT SOURCE: LOW PROFILE, VAPOR TIGHT, LED LIGHT SOURCE)	STANDARD	MOVOLT	WALL	LITHONIA	OLVTWM-	APPROVED ALTERNATE	APPROVED ALTERNATE	ON/OFF	GENERATOR YARD	
	L3		NOT USED										
	L3A		NOT USED										
	L4	23W LED, 1800+ DELIVERED LUMENS, 3500K, 80+ CRI, 50000 HOURS	4" DIAMETER RECESSED FIXED DOWNLIGHT, 73 DEGREE WIDE BEAM DISTRIBUTION, MATTE- DIFFUSE REFLECTOR, 6-8/16" TALL NEW CONSTRUCTION HOUSING, INTEGRAL DRIVER.	STANDARD, TO BE CONFIRMED WITH ARCHITECT	120-277	RECESSED	GOTHAM	EY04-35/20-AR- WD-LD-MVOLT- GZ10	COOPER PORTFOLIO SERIES	SIGNIFY CALCULITE SERIES	0-10V DIMMING	CORRIDORS	PROVIDE ADDITIONAL QUANTITY OF COMPLETE LIGHT FIXTURE, WITH A QTY OF 0.25% OF TOTAL QTY AND A MIN. QTY OF 2 FIXTURES.
	L4A		NOT USED										
	L4B		NOT USED										
	L5	20W, 2000 LUMENS, 3500K, 85 CRI, 50,000 HOURS	4" DIAMETER CYLINDER DOWNLIGHT, 65 DEGREE WIDE BEAM DISTRIBUTION, MATTE-DIFFUSE REFLECTOR, 6-8/16" TALL NEW CONSTRUCTION HOUSING, INTEGRAL DRIVER.	WHITE (VERIFY WITH ARCH)	120-277	PENDANT	GOTHAM	EY04CC-35/20- AR-LD-MVOLT- GZ10	COOPER PORTFOLIO SERIES	SIGNIFY CALCULITE SERIES	ELV / 0-10V DIMMING	CORRIDORS	
	L5A		NOT USED										
	L6		NOT USED										
	L6A	9W/FT, 1250 LUMENS PER FOOT, 3500K, 80+ CRI, 50, 000+ HOURS	3.44" WIDE X 2.72" DEEP LED STRIPLIGHT WITH DIFFUSE LENS, PROVIDE SURFACE OR PENDANT MOUNT SUPPORTS PER MOUNTING HEIGHT. LENGTH PER PLAN	WHITE, VERIFY WITH ARCHITECT	120-277	WALL	LITHONIA	GLX L24 2500LM SEF FDL	COOPER METALLUX SNLED SERIES	DAYBRITE FSS LED SERIES	0-10V DIMMING	STAIRS/ CORRIDORS	
	L6B		NOT USED										
SITE FAÇADE													
	S1	Lamp 5603 LUMENS, 55W, 3000K, 80 CRI	Description SIMILAR TO F1, EXCEPT WALL MOUNTED	Finish BLACK (VERIFY WITH ARCH)	Voltage 120/277V	Mounting WALL	Manufacturer WE-EF	Catalog Number ASPS34 LED655- 3526	Alternate 1 APPROVED ALTERNATE	Alternate 2 APPROVED ALTERNATE	Control 0-10V DIMMING	Location	Comments ARM MOUNTED
	S2	7.7W, 807 LUMENS, 3000K, 80 CRI	10.31" WIDE X 9.06" TALL X 4.52" DEEP RECESSED STEP LIGHT WITH TEMPERED GLASS LENS, ASSYMETRIC THROW, WET LOCATION RATED.	GREY METALLIC (VERIFY WITH ARCHITECT)	120-277V	RECESSED	WE-EF	QRI 354 LED - 616 1321	APPROVED ALTERNATE	APPROVED ALTERNATE	ON/OFF	STEPS	
	S3	8W, 1080 LUMENS, 2700K, 80 CRI	3.8" DIAMETER SEMI-RECESSED LUMINAIRE WITH BLADE OPTICS FOR VERY TIGHT BEAM CONTROL. FIXTURE SHALL BE WET RATED FOR INSTALLATION WITHIN STONE WALL.	STAINLESS STEEL	120-277V	RECESSED	INTER-LUX	E84316-M	APPROVED ALTERNATE	APPROVED ALTERNATE	0-10V DIMMING	ESCALATOR CANOPY	
EMERGENCY													
	X1	Lamp 5W LED GREEN/RED	Description EDGE LIT EXIT SIGN, PROVIDE WHITE OR MIRROR BACKING BETWEEN PANELS - TBD, MOUNTING AND ARROWS, SINGLE OR DOUBLE FACE, WITH UNIVERSAL MOUNTING FOR ALL CONDITIONS PER PLAN DRAWINGS	Finish BRUSHED ALUMINIUM	Voltage 277	Mounting UNIVERSAL	Manufacturer LITHONIA	Catalog Number LRP SERIES	Alternate 1 COOPER	Alternate 2 SIGNIFY	Control	Location PREMIUM AREAS	Comments VERIFY LETTER & BACKGROUND COLOR WITH LOCAL AHJ



2305 Mount Werner Circle
Steamboat Springs, CO 80487

Gensler

1225 17th Street
Suite 150
Denver, CO 80202
United States

Tel 303.595.8586
Fax 303.625.6823



141 9th Street
PO Box 774943
Steamboat Springs, CO
80477
Tel 970.871.9494

DESIGNWORKSHOP

1390 Lawrence Street
Suite 100
Denver, CO 80204
Tel 303.623.5186



12499 West Cofax Ave.
Lakewood, CO 80215
United States
Tel 303.431.6100



14143 Denver West Pkwy
Suite 300
Golden, CO
United States
Tel 303.421.6655

△	Date	Description
	2021.05.19	BP3: GOLDWALK - ISSUE FOR BID AND PERMIT
1	2021.07.01	BP3: GOLDWALK - BULLETIN 03 - PERMIT RESPONSES

Seal / Signature



Project Name

SSRC | BASE AREA
IMPROVEMENTS

Project Number

003.7835.000


Description

ELECTRICAL EQUIPMENT
CONNECTION AND LIGHT FIXTURE
SCHEDULE

Scale

NOT TO SCALE

1B-E0.002

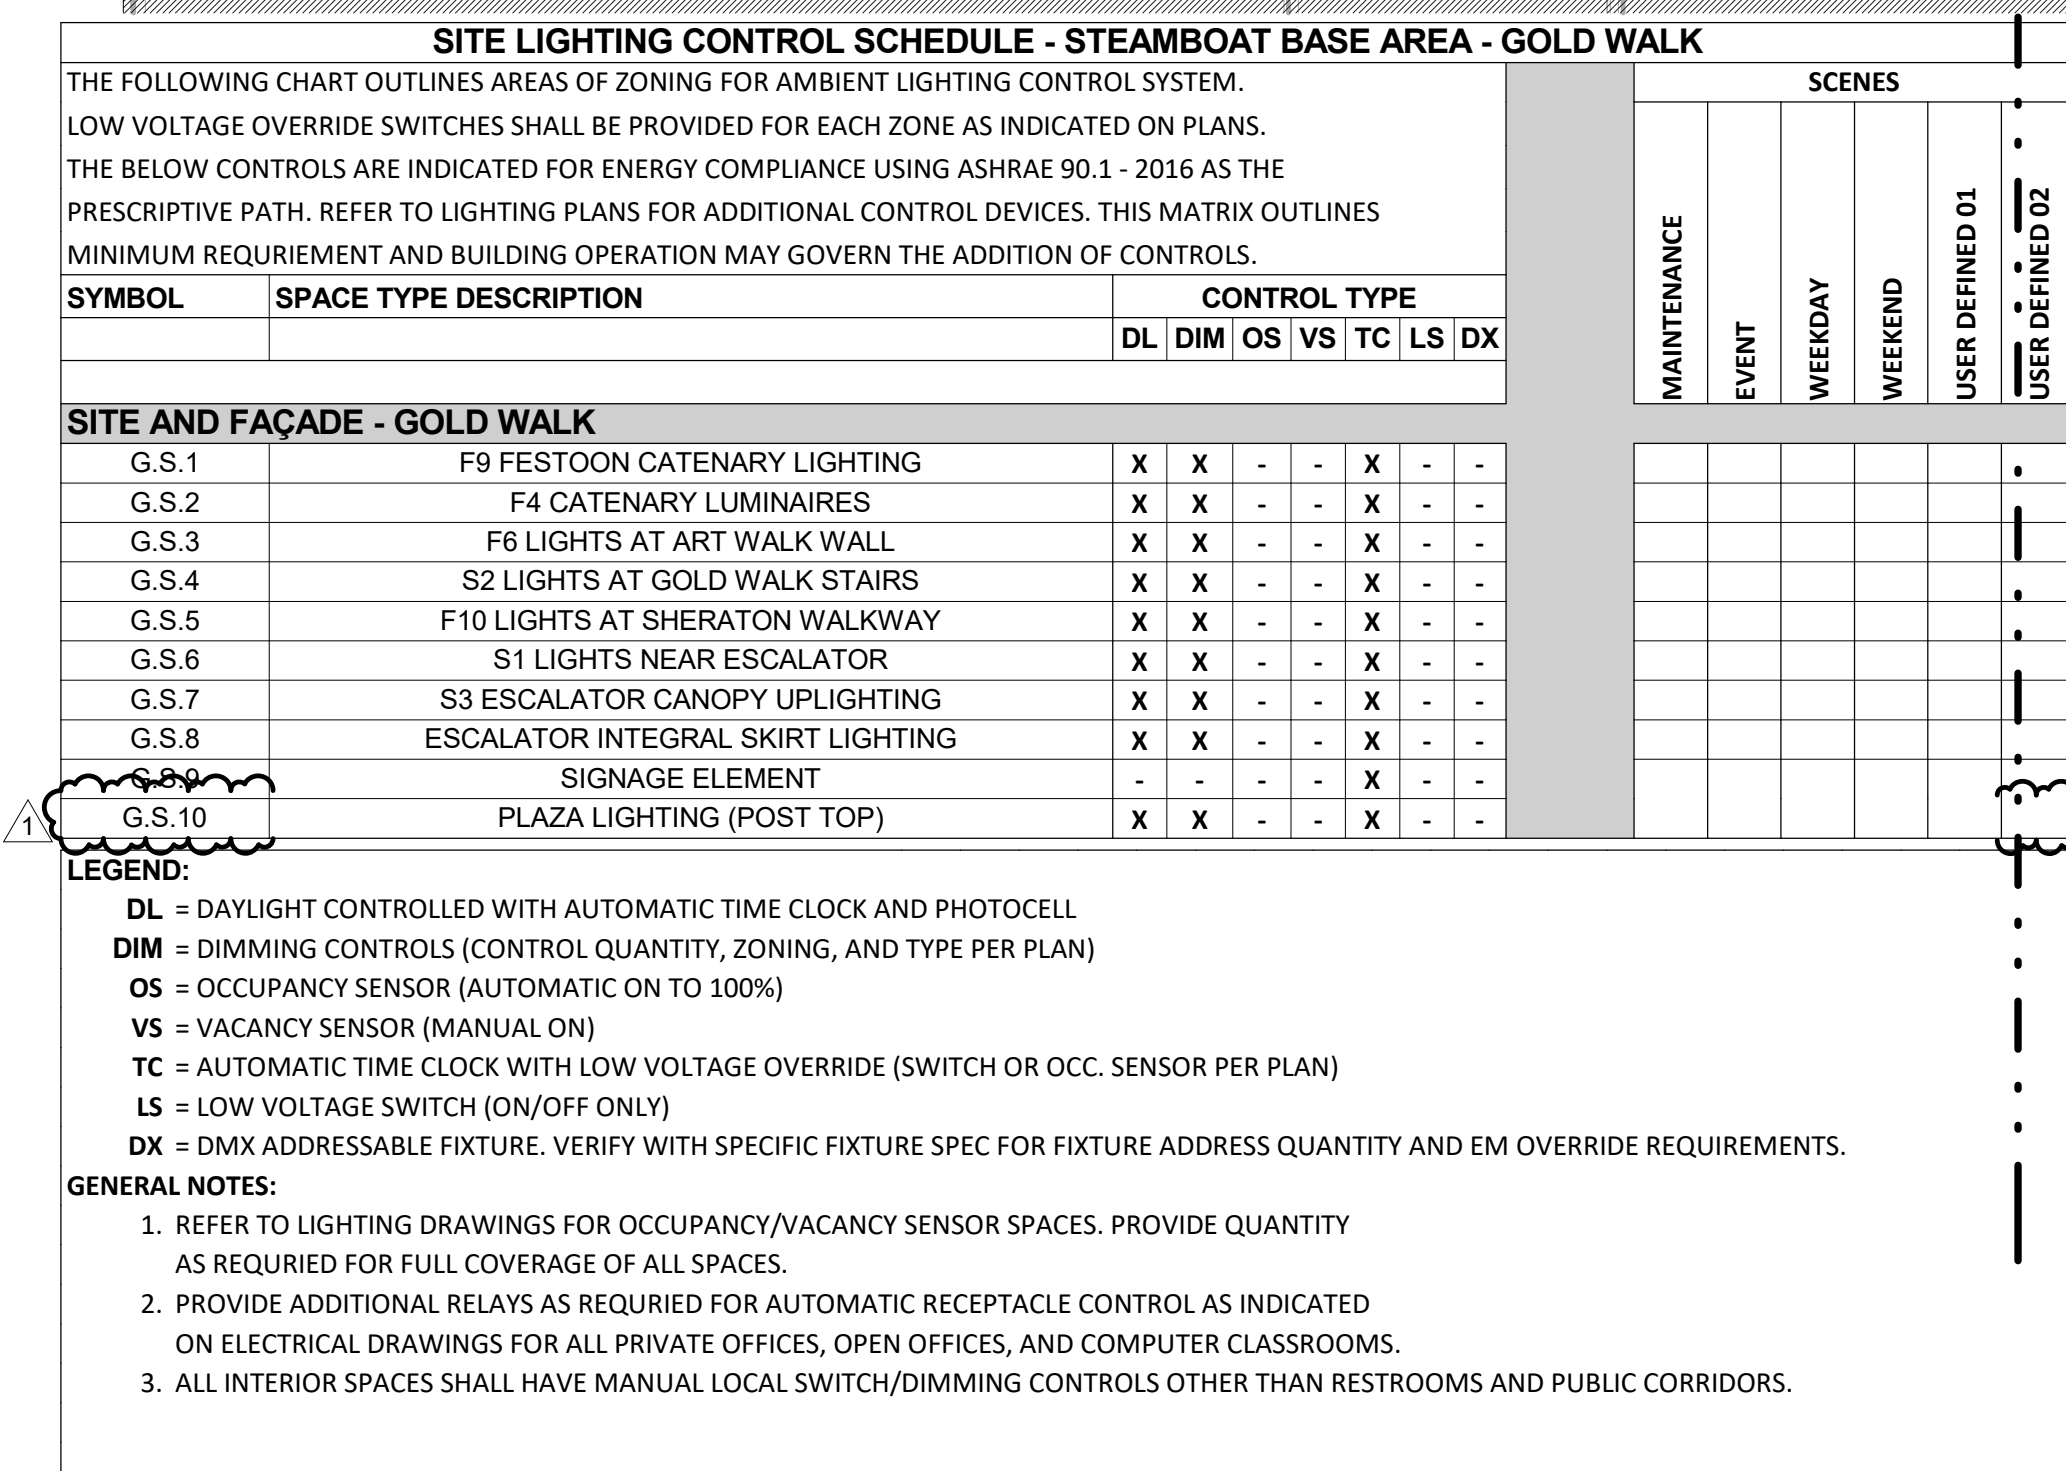

SCALE: 1/8" = 1'-0"

© 2021 Gensler