

HOTEL A & HOTEL B
Site Development Package
3400 S. LINCOLN AVE
STEAMBOAT SPRINGS, CO 80487

* This document (whether in hard copy or electronic file format) is the property of Design 2 Function, LLC and is part of our instruments of service. The information contained in this drawing shall not be used for any purpose other than for the construction of the referenced project. Any other use, reuse or modification of the print or electronic file without our prior written consent is expressly prohibited and, if done so, will be at the requester's sole risk and without liability or legal recourse to Design 2 Function, LLC.

* Due to variation in printing techniques, only printed dimension shall be used. Contractors shall verify all details, dimensions and other related information prior to bidding or construction.

DRAWING ISSUE DATES:
2/20/23 Site Development Package

DRAWING REVISION DATES:


PROJECT MANAGER:
NICK PIRKL

DRAWN BY:
NAP


SHEET TITLE:
SITE LIGHTING
PLAN

SHEET NO.

C11

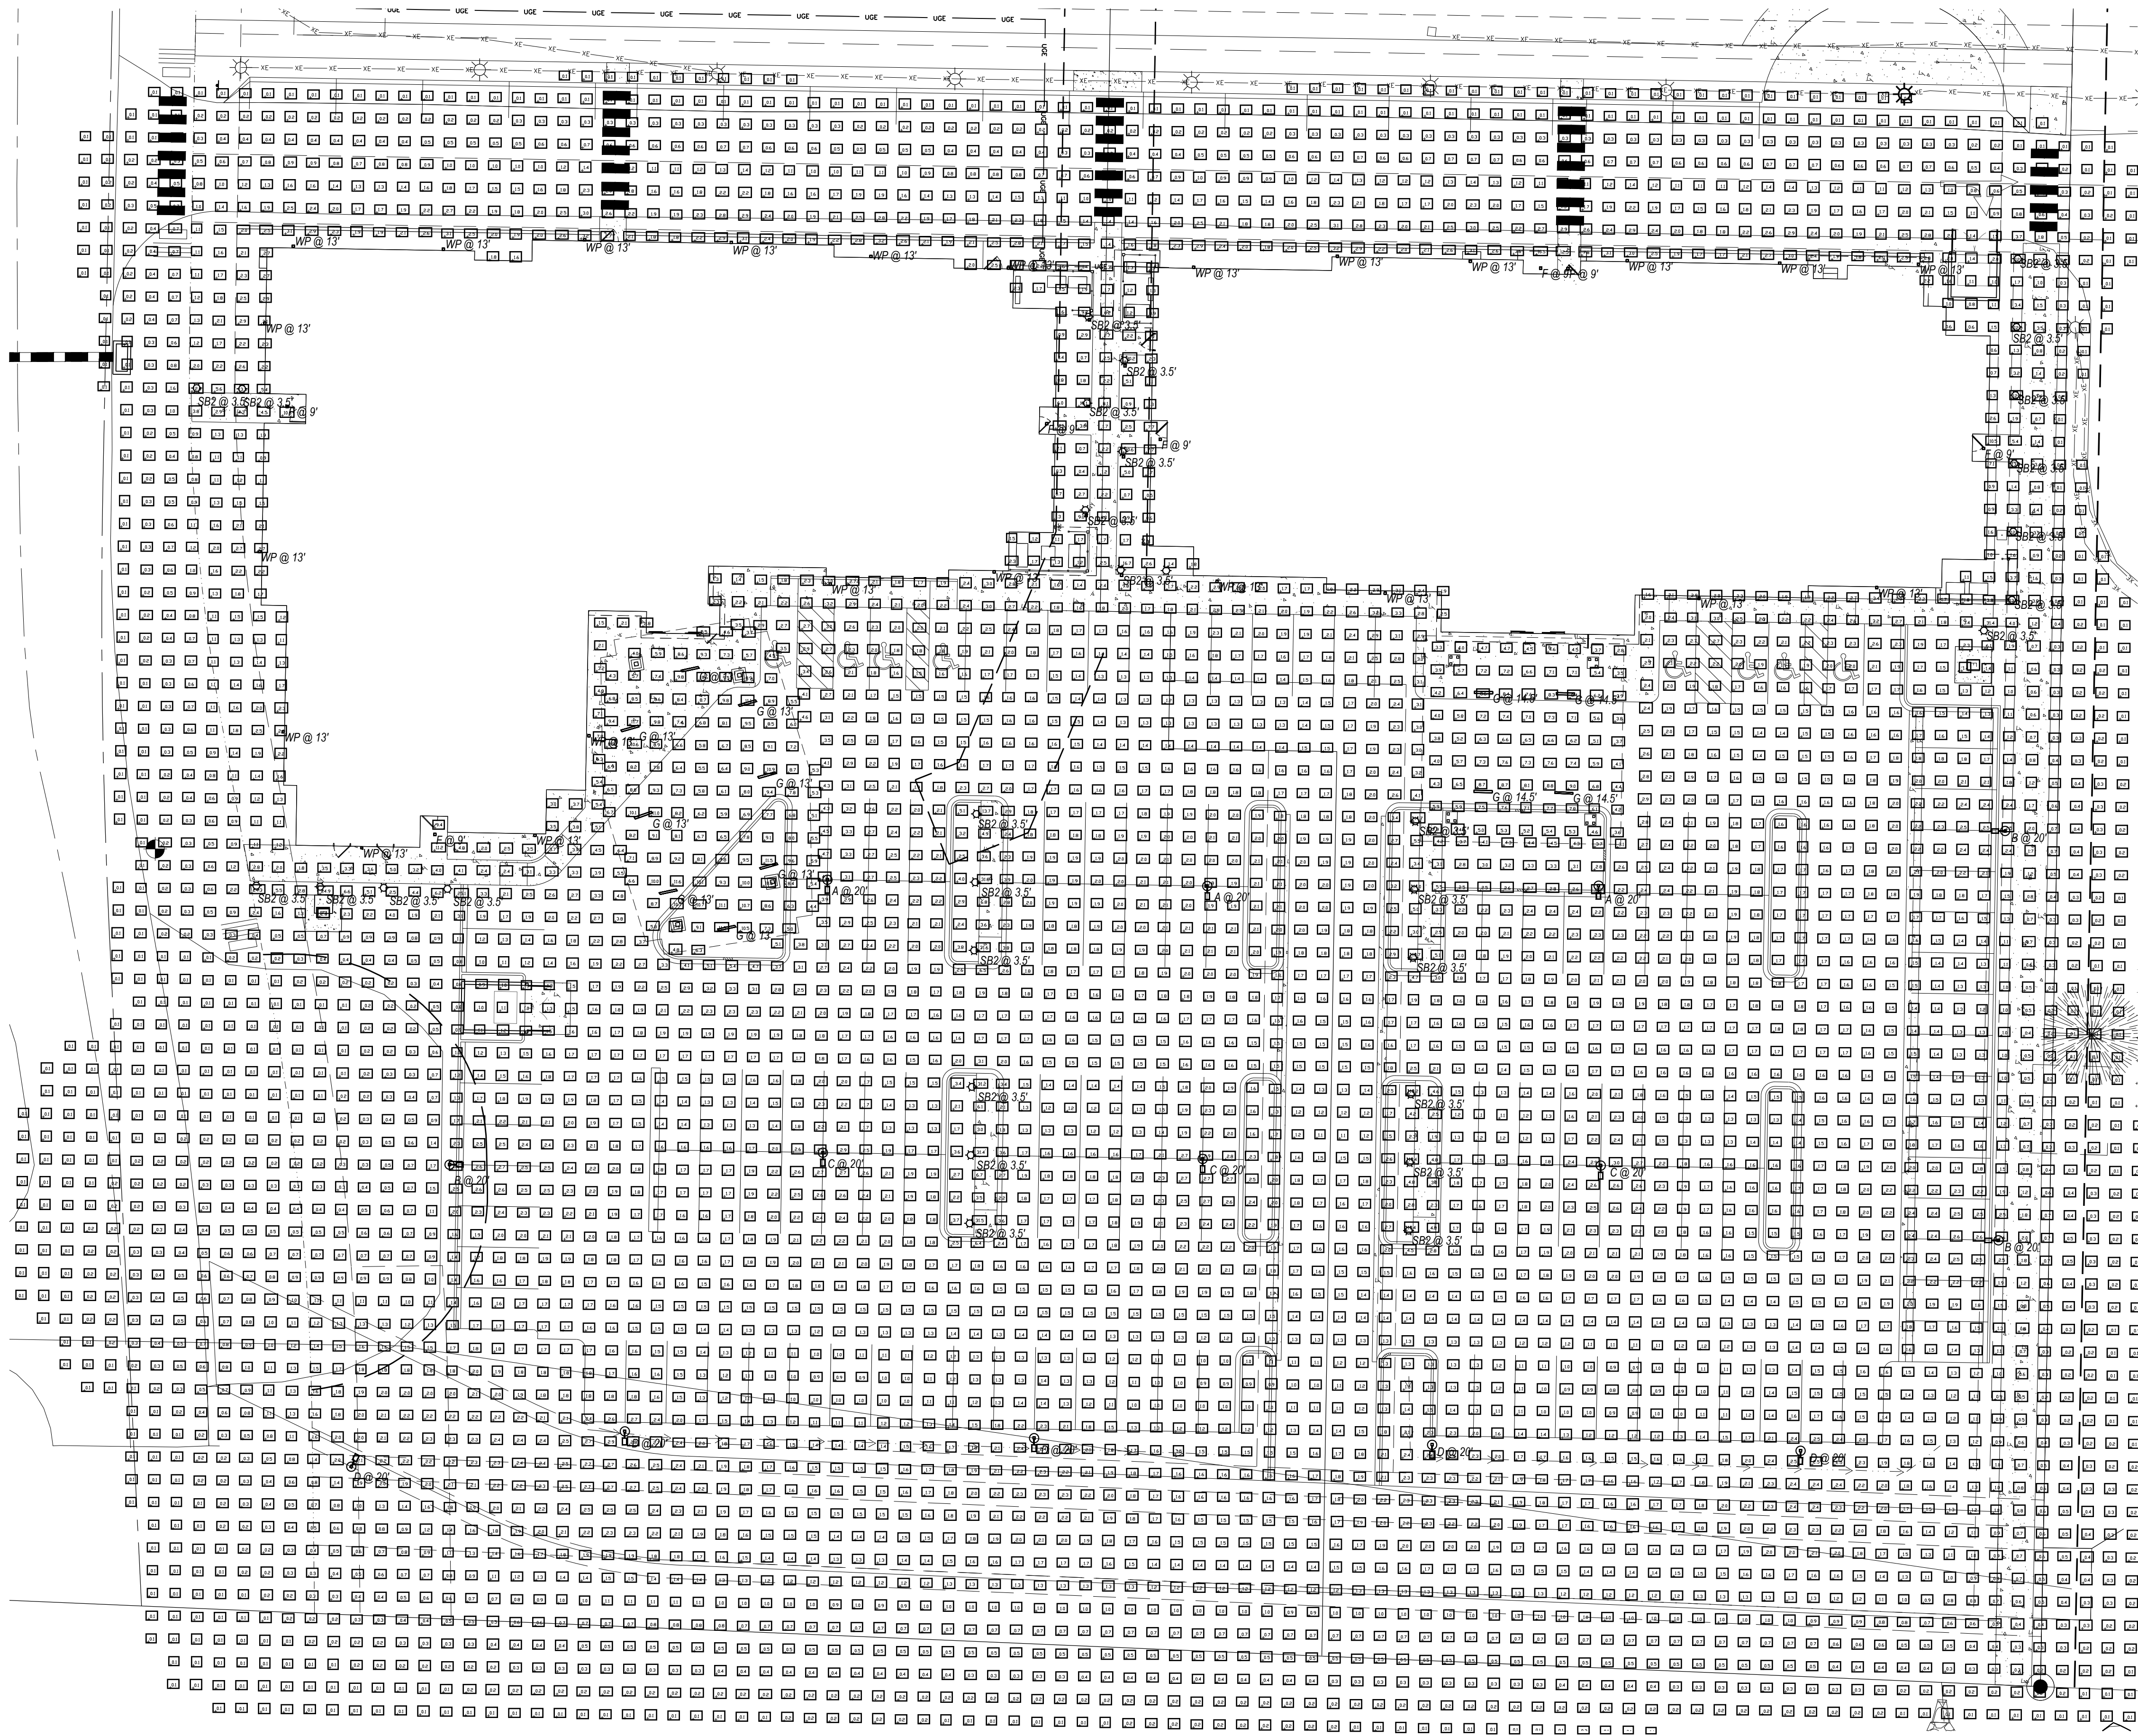

SITE LIGHTING PLAN
SCALE: 1"=20'-0"

 

NOTE:
ALL EXTERIOR LIGHT FIXTURES ARE TO BE INSTALLED IN A
DOWN-CAST CONFIGURATION. THIS INCLUDES THE TYPE "G"
FIXTURE IN THE PORTE COCHERE AND THE "WP" WALL MOUNTED
LIGHT FIXTURES

LUMINAIRE SCHEDULE						
LABEL	QUANTITY	MANUFACTURER	CATALOG #	LUMENS PER LAMP	FIXTURE WATTS	TOTAL WATTS
A	3	Lithonia	DSX1 LED P3 40K 70CRI T5M	14372	102	306
B	3	Lithonia	DSX1 LED P2 40K 70CRI T4M HS (houseside shield)	8524	68	204
C	3	Lithonia	DSX1 LED P1 40K 70CRI T4M	9909	68	204
D	5	Lithonia	DSX1 LED P1 40K 70CRI T3M HS (houseside shield)	6582	51	255
F	7	Lithonia	LDN6 40/10 L06AR LD (recessed can)	851	11	77
G	12	Precision	ML5WL-VD-MO/HO-K40-4-X-LOH/LOH-X-X-UNV	5196	53	636
SB2	31	Lithonia	RADB LED P2 40K SYM DBLXD	617	8	248
WP	24	Lithonia	WSQ LED P1 SR3 40K MWOLT	2244	20	480
TOTALS	88					2410