 


LIGHTING LEGEND

- STREET LIGHTS - CITY
- PLAZA LIGHT - MULTI-HEADED
- CUSTOM - PEDESTRIAN
- CUSTOM - PEDESTRIAN EXISTING
- CUSTOM - PEDESTRIAN RELOCATE
- CUSTOM - PEDESTRIAN REDUCED \$
- STRING LIGHTS
- BOLLARD LIGHT
- STEP LIGHT
- WALL LIGHT
- BUILDING LIGHT



NOTES:
1. DURING THE DESIGN DEVELOPMENT PHASE, THE PLAN SHALL BE INFORMED BY A PHOTOMETRIC ANALYSIS AND THE CITY'S AGREEMENT WITH YAMPA VALLEY ELECTRIC ASSOCIATION (YVEA) FOR PROVIDING LIGHT STANDARDS.

STEAMBOAT
GONDOLA TRANSIT
CENTER
Steamboat, CO

REVIEW SET
NOT FOR CONSTRUCTION
These documents are incomplete, are released for interim review only, and are not intended for bidding or construction purposes.
12/20/23

KEY PLAN:

REVISIONS:		
#	DATE	DESCRIPTION
DRAWN: SB/AMJC		REVIEWED: JC/NH

PROJECT NUMBER: 22077
DATE: DECEMBER 20, 2023

100%
SCHEMATIC
DESIGN

CONCEPTUAL
LIGHTING PLAN

SHEET:

L.400



01 STREET LIGHTS - CITY



02 PLAZA LIGHT - MULTIHEAD



03 CUSTOM PEDESTRIAN



04 CUSTOM PEDESTRIAN EXISTING



05 CUSTOM PEDESTRIAN RELOCATE




06 CUSTOM PEDESTRIAN REDUCED




07 STRING LIGHTS



08 BOLLARD LIGHTS

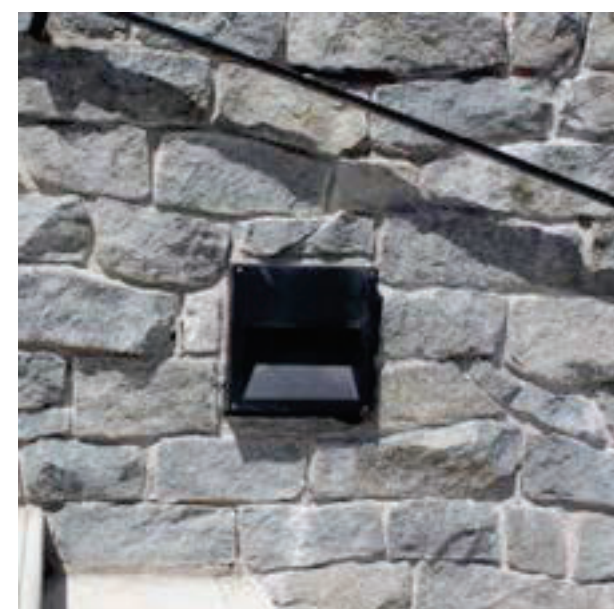

09 STEP LIGHTS

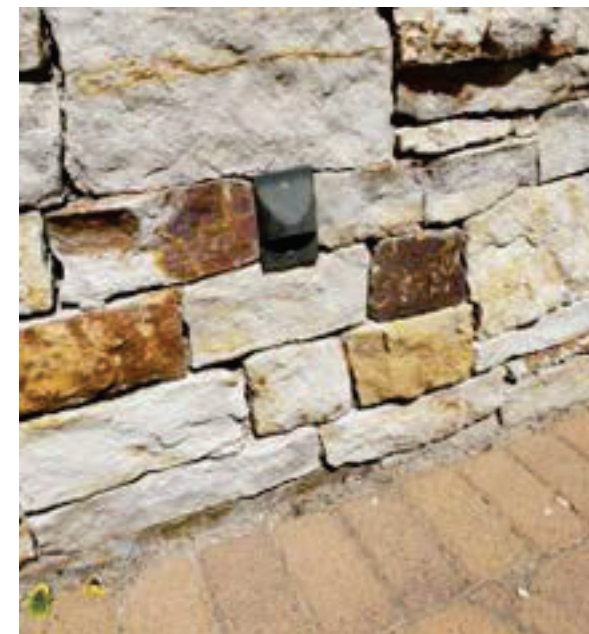

10 WALL LIGHT



11 BUILDING LIGHT

STEAMBOAT GONDOLA TRANSIT CENTER Steamboat, CO

REVIEW SET
NOT FOR CONSTRUCTION
These documents are incomplete,
are released for interim review
only, and are not intended for
bidding or construction purposes.
12/20/23

KEY PLAN:

REVISIONS:		
#	DATE	DESCRIPTION
DRAWN: SB/AMJC REVIEWED: JC/NH		


PROJECT NUMBER: 22077
DATE: DECEMBER 20, 2023

100%
SCHEMATIC
DESIGN

CONCEPTUAL
SIGNAGE PLAN

SHEET:

L.401

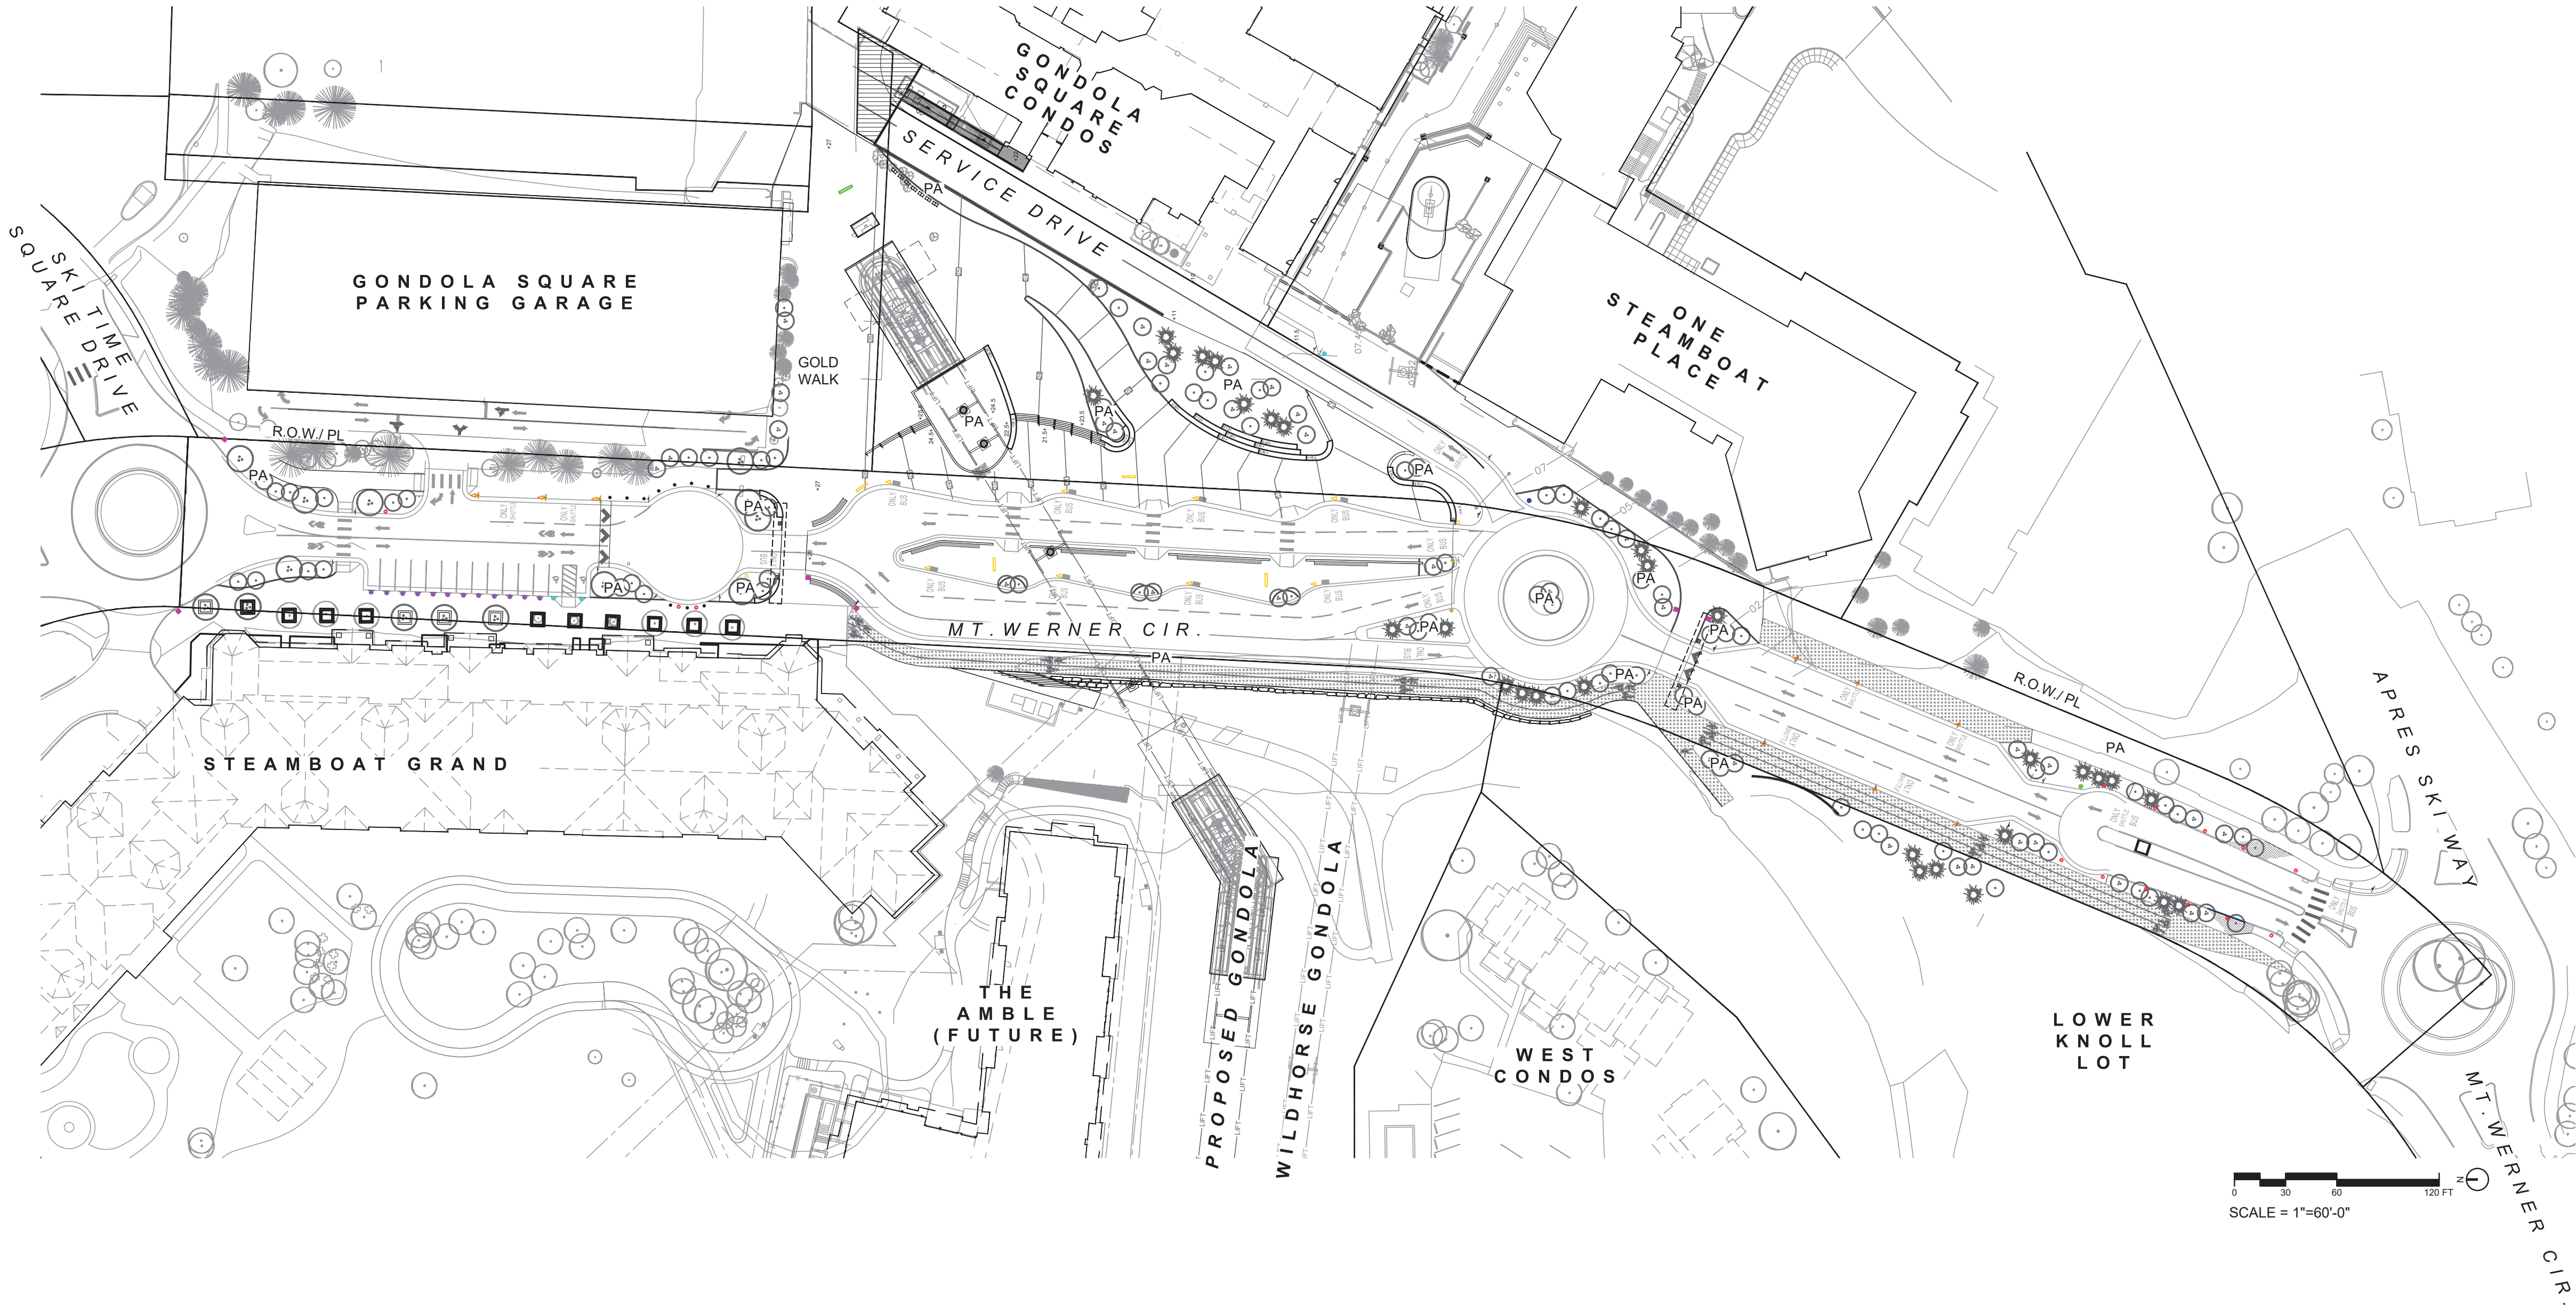

SIGNAGE LEGEND

- "BUS ONLY" SIGN
- "BIKE DISMOUNT ZONE" SIGN
- "APPROVED VEHICLES ONLY NO PRIVATE VEHICLES" SIGN
- "NO PASSENGER DROP OFF" SIGN
- "NO PASSENGER DROP OFF SHUTTLE PARKING ONLY" SIGN
- "SERVICE VEHICLES FOR SHERATON ONLY" SIGN
- ADA PARKING SIGN
- ADA DROP OFF SIGN
- "2 HOUR PARKING FOR CUSTOMERS ONLY" SIGN
- ▲ SHUTTLE SERVICE SIGN
- ▲ BUS ROUTE SIGN
- BUS TIMETABLE SIGN
- DIRECTORY SIGN