



 
 
 
 


Issue	By	Date & Issue Description	By
—		DEVELOPMENT PLAN — 3.19.25	AW

Scale:	1"=20'-0"
	24x36
Description:	ELECTRICAL PHOTOMETRIC PLAN
Project Name:	COMPLETE STREETS 48 PH2
Project Number:	2018082
Sheet No.	E-1.0

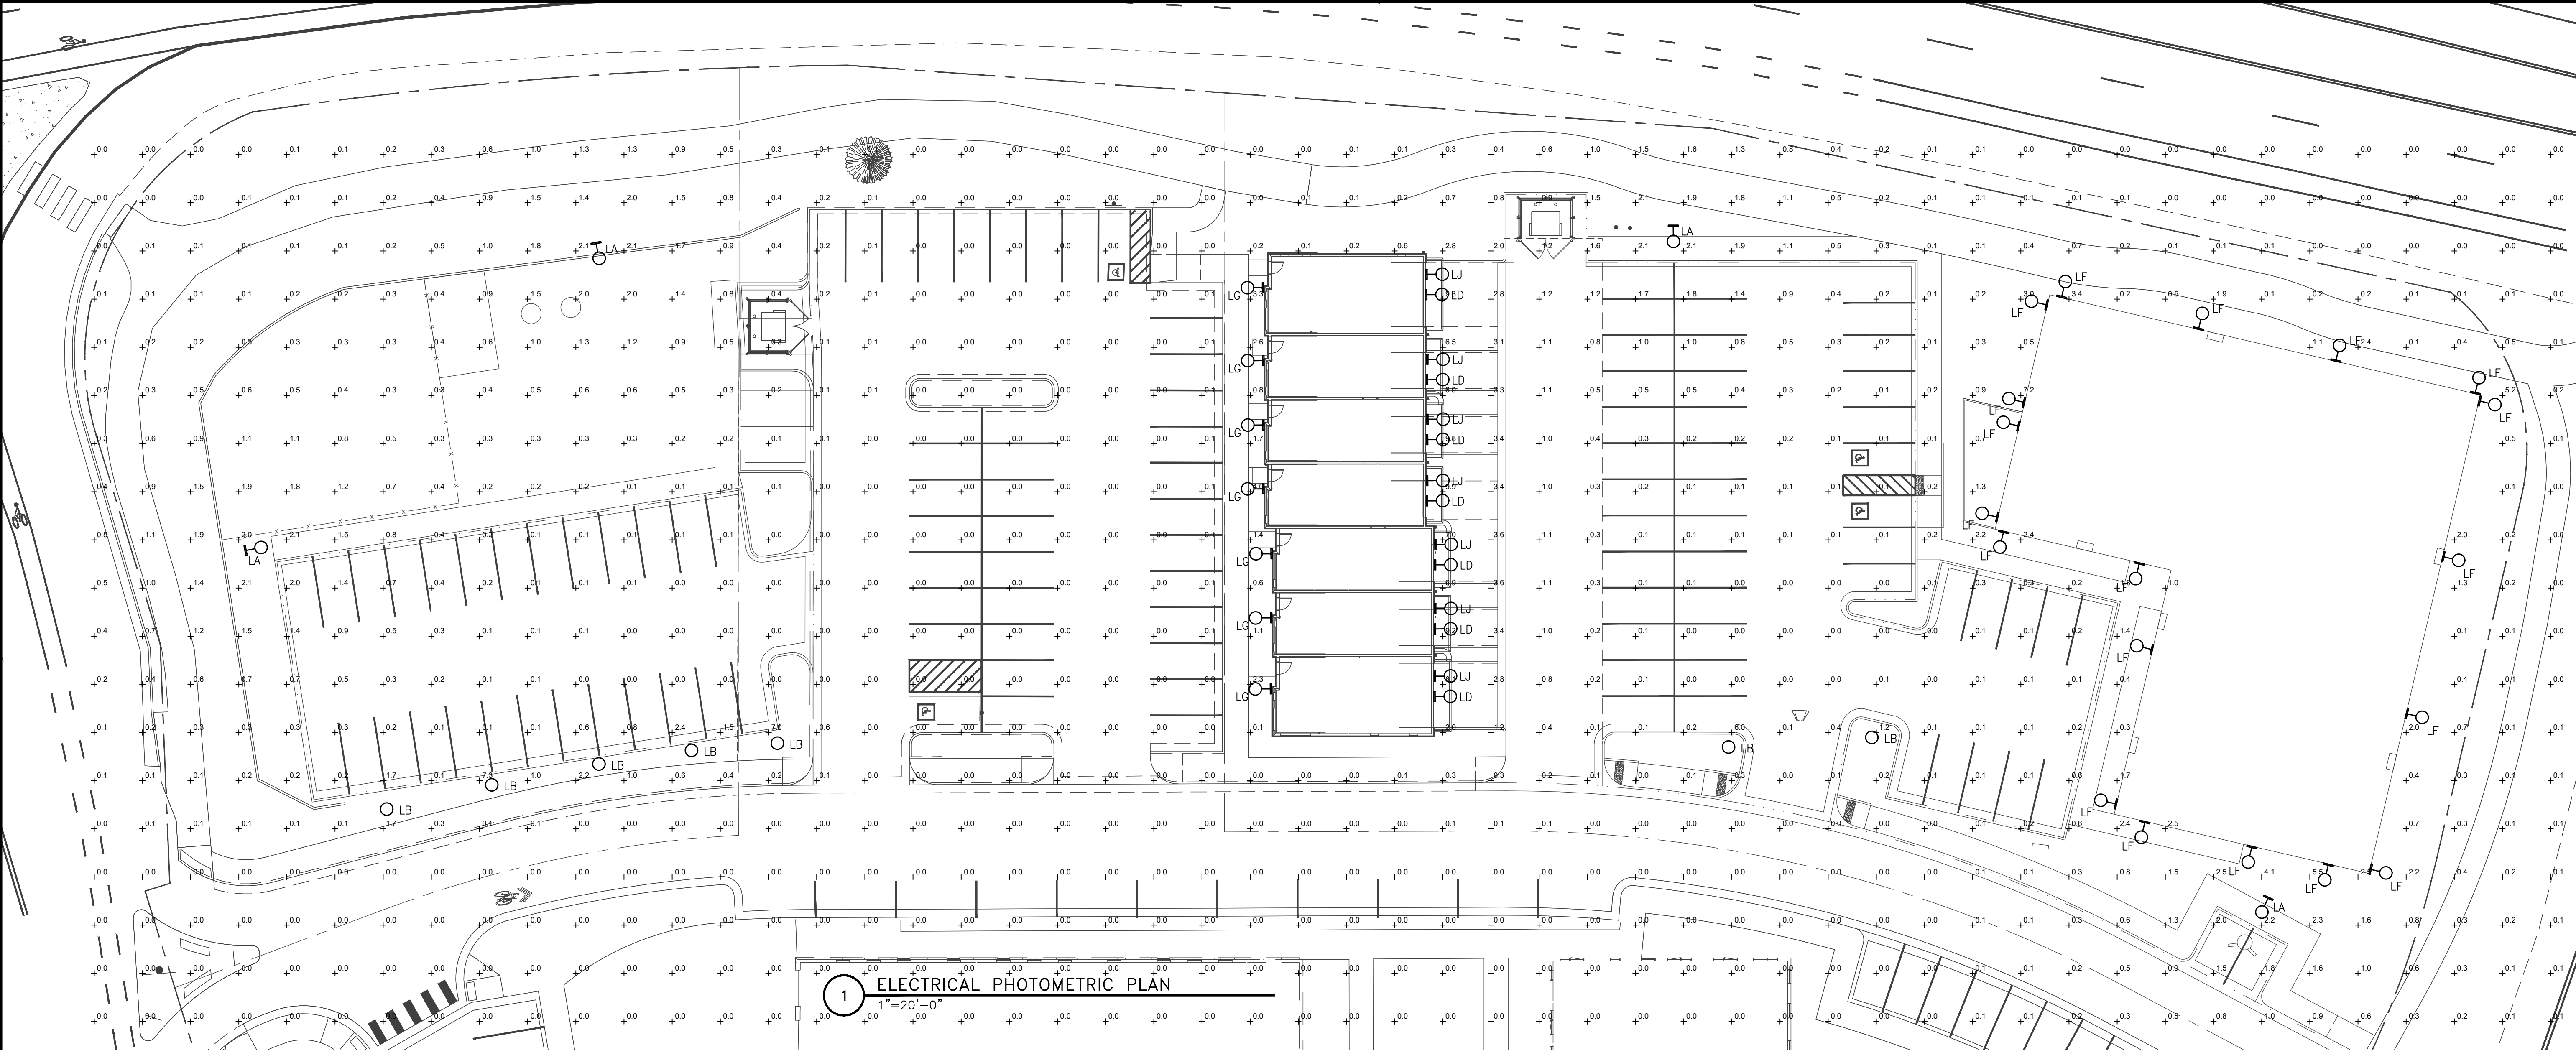



GENERAL NOTES
1. CALCULATION VALUES ARE IN FOOTCANDLES.

LIGHTING FIXTURE SCHEDULE									
SYMBOL	ITEM	TYPE	MOUNTING HEIGHT	SIZE	LAMPS		FIXTURE VOLTAGE	INPUT WATTS	CATALOG NUMBER
					TYPE	COLOR			
	LA	PARKING LOT AREA FIXTURE	20'	24"D	LED	3500	TBD	85	LITHONIA LIGHTING RAD1-LED-P4-35K
	LB	EXTERIOR BOLLARD	42"	8"D	LED	4000	TBD	22	LITHONIA LIGHTING KBD8-LED-16C-530-40K
	LD	BUILDING MOUNTED PENDANT	8'	12"D	LED	3000	TBD	27	BAR LIGHT ELECTRIC LIGHTING DBW12-G
	LF	BUILDING MOUNTED WALL PAK	6'	8"D	LED	3000	TBD	12	SONNEMAN LIGHTING 7472.72-WL
	LG	BUILDING MOUNTED WALL PAK	6'	4"x10"	LED	3000	TBD	11	WAC LIGHTING WS-W36610
	LJ	BUILDING MOUNTED WALL PAK	16'-9"	6"x6"	LED	3000	TBD	20	TECH LIGHTING 700WSPIT-S-B-LED830

2 FIXTURE SCHEDULE
NTS

Steamboat Basecamp, Lot 2
Steamboat Springs, CO

7200 Wisconsin Ave #500
Bethesda, MD 20814

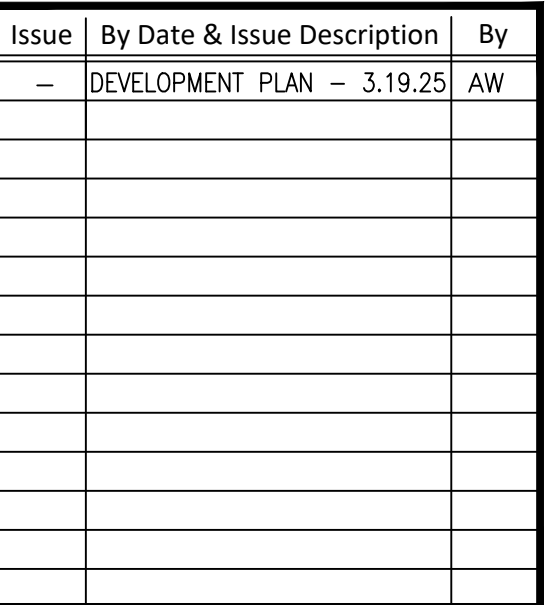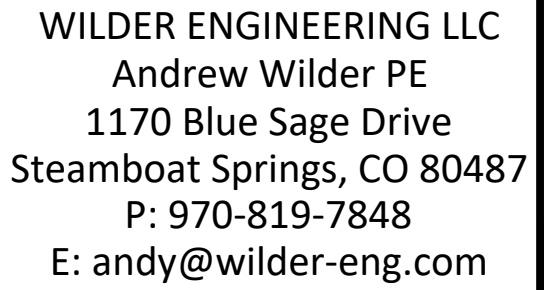

Project Name: COMPLETE STREETS 4B PH2
Project Number: 2018082

Sheet No.

E-1.1

4 FIXTURE LF
NTS

5. **FIXTURE LG**
NTS

6 FIXTURE LJ
NTS

1 FIXTURE LA
NTS

2 FIXTURE LB
NTS

3 FIXTURE LD
NTS

Project Name: COMPLETE STREETS 4B PH2
Project Number: 2018082

Sheet No.

E-1.1