



L3 12.8"H X 14.4"W
 BLACK
 TO USE PAR 20 BULB



L2 11.5"H X 8.2"W
 BLACK + CLEAR GLASS
 LED G9 IS RECESSED INTO FIXTURE

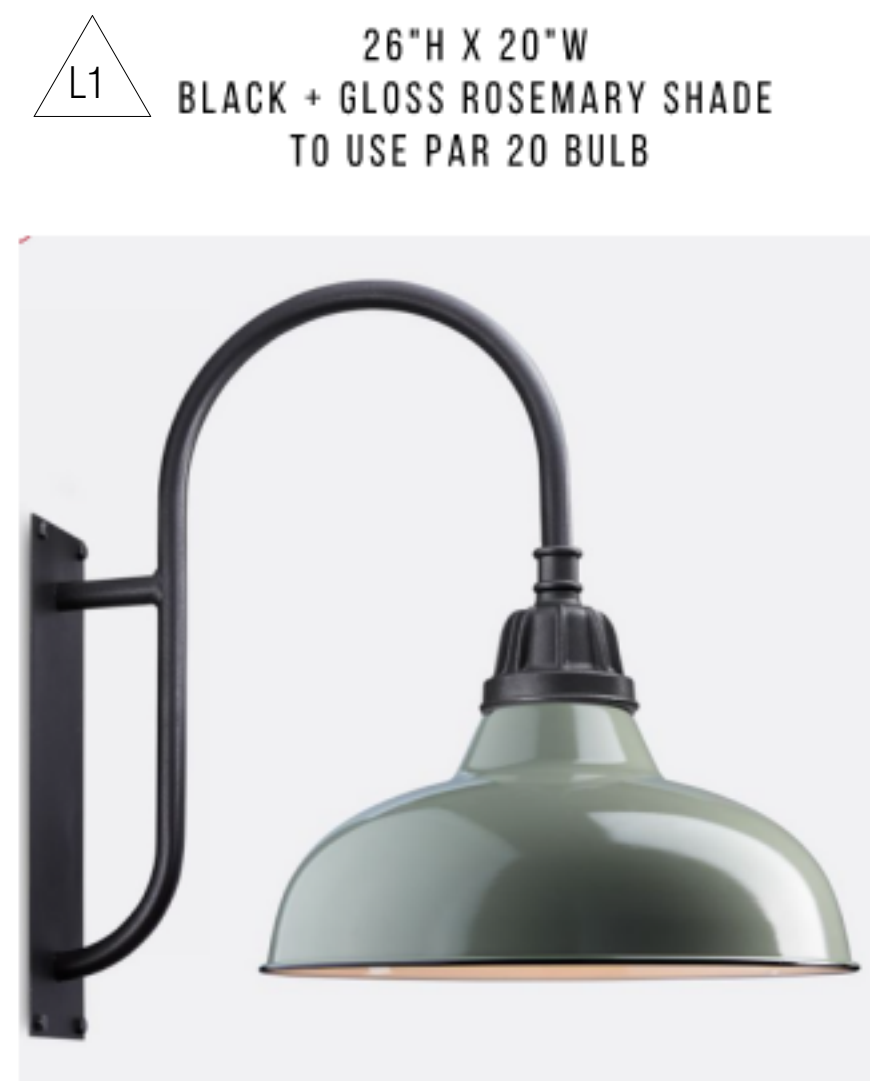

L1 26"H X 20"W
 BLACK + GLOSS ROSEMARY SHADE
 TO USE PAR 20 BULB

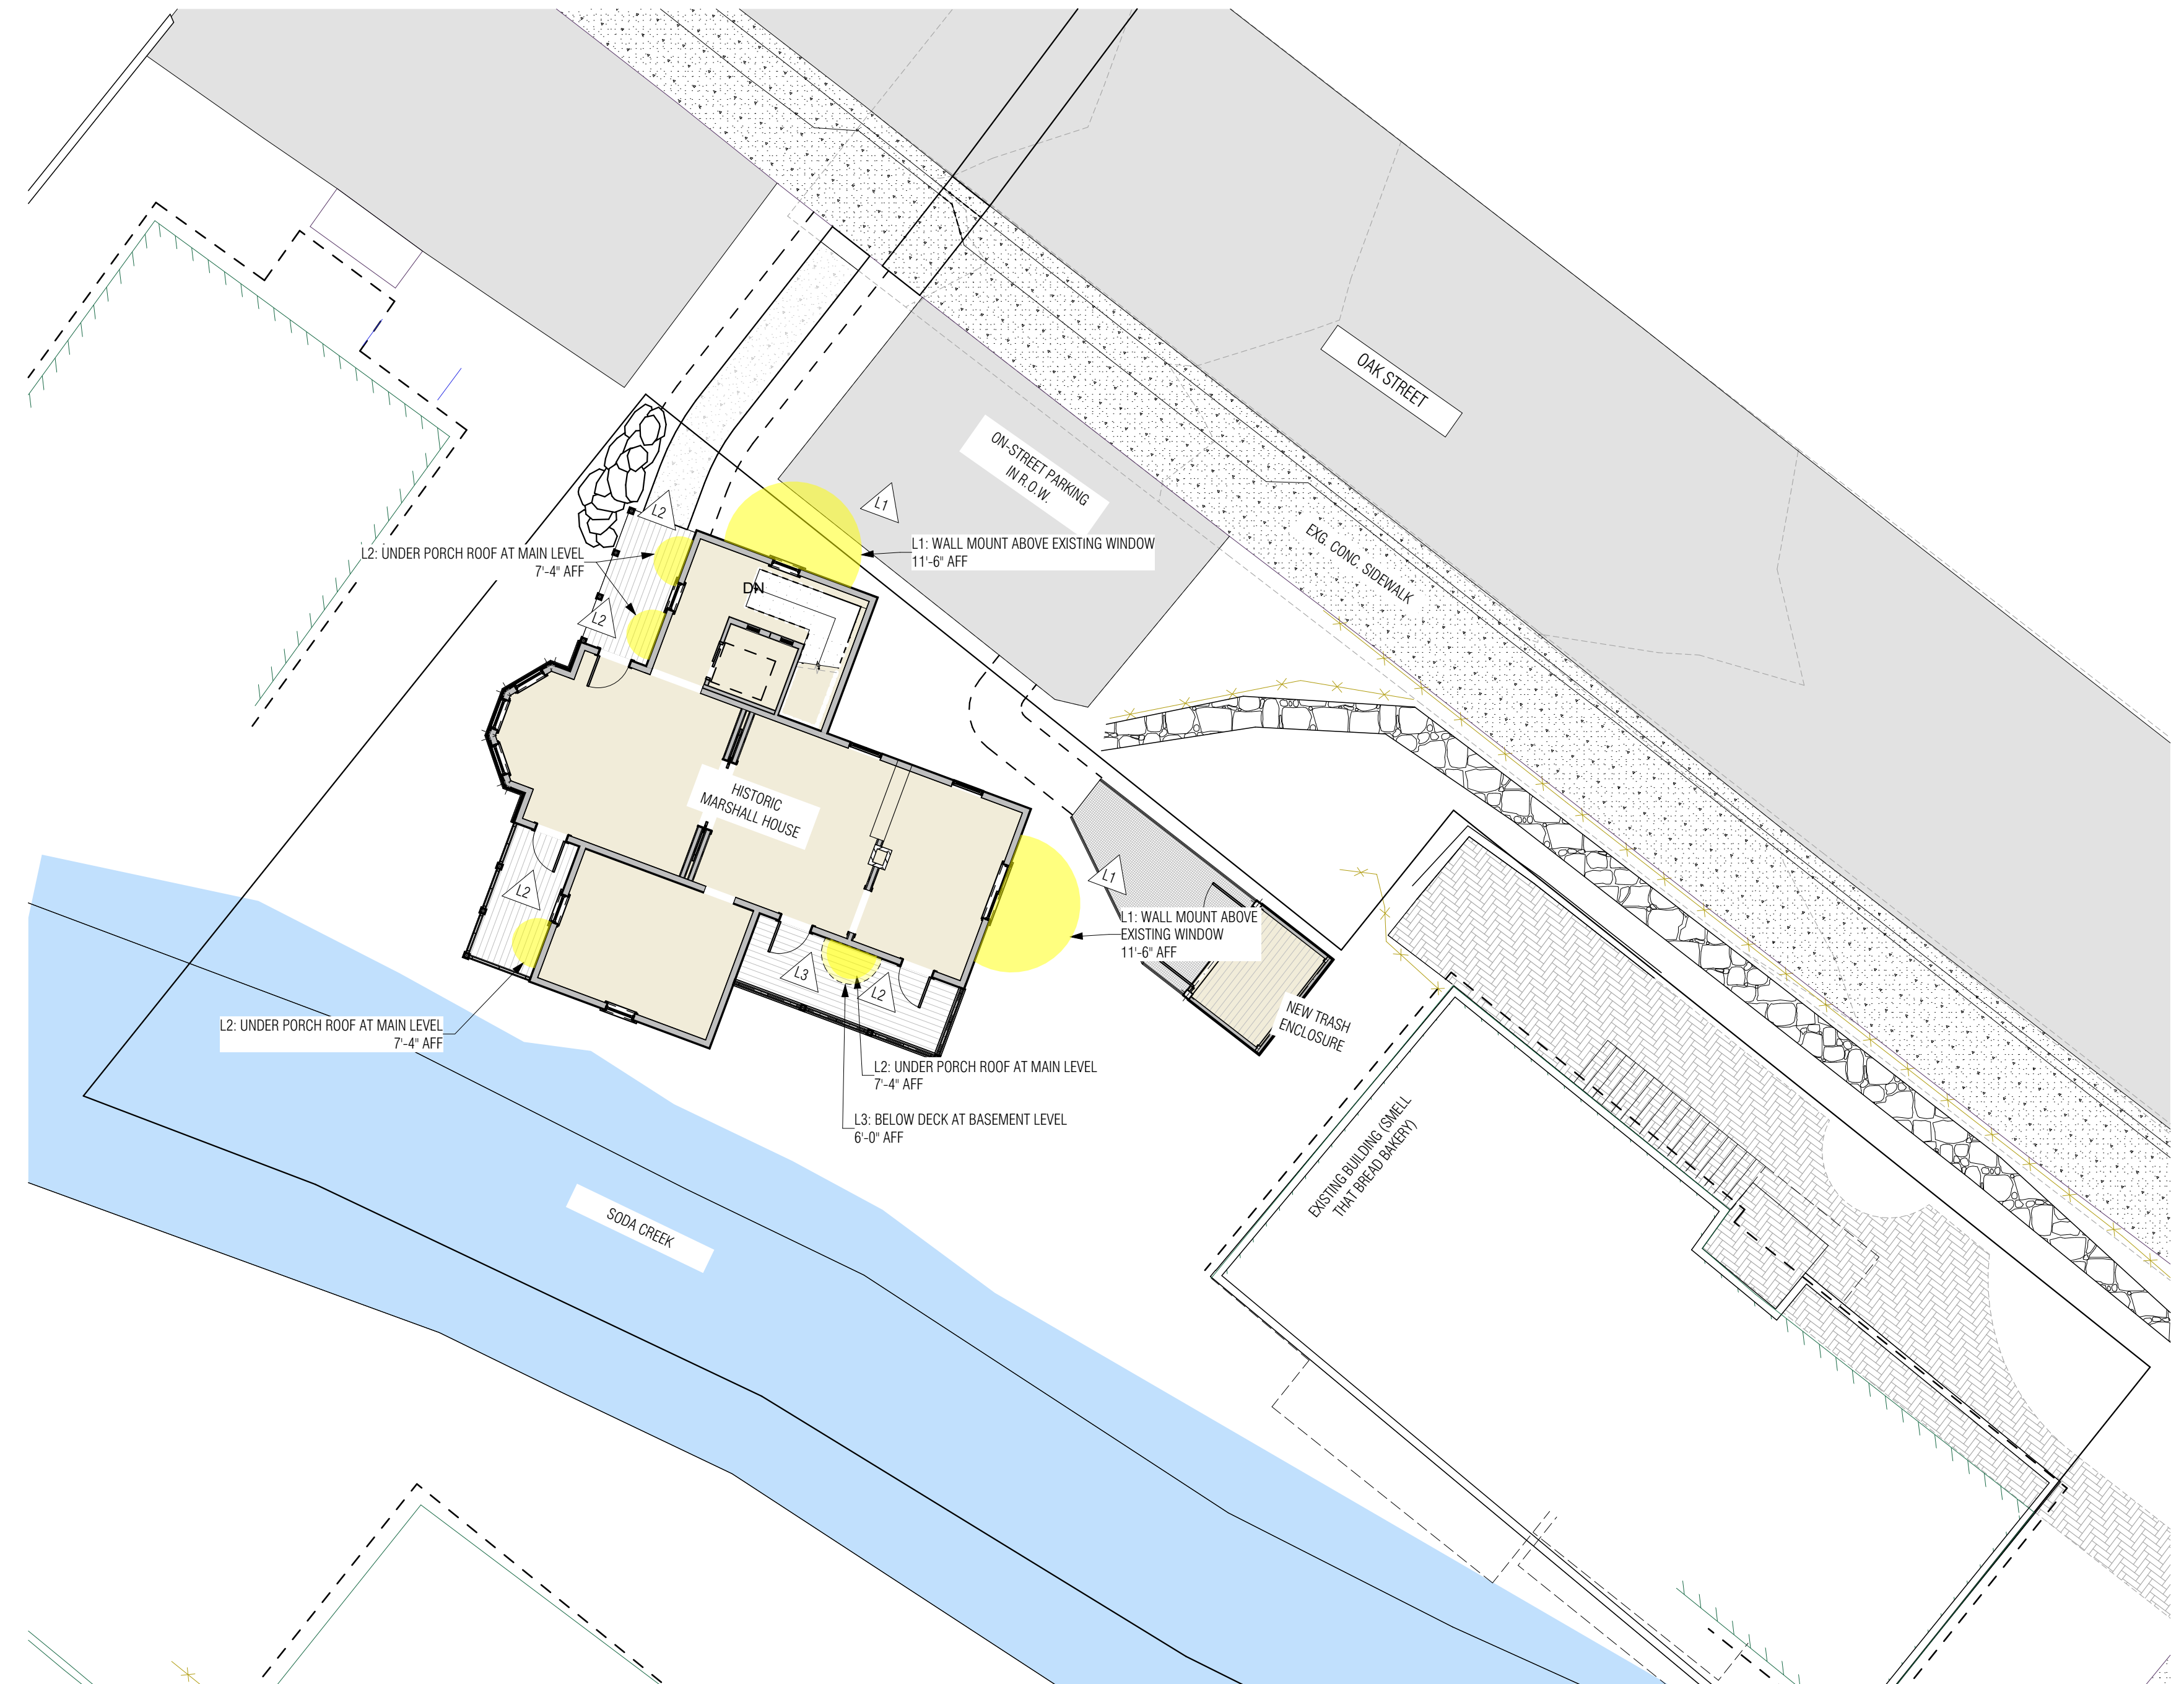

1 EXTERIOR LIGHTING PLAN
 SCALE: 1" = 10'