


NOTES:
- SITE WAS CONSIDERED FLAT, NO SLOPE WAS CONSTRUCTED
- ALL LUMINAIRES ARE MOUNTED 30FT AFF

Luminaire Schedule							
Symbol	Qty	Label	Arrangement	Luminaire Lumens	LLF	Description	Filename
	102	SN	Single	17663	0.900	Snow Bright SNBT-FL-300WB2-300W-NF-65K PTB	SNBT-FL-300WB2-NF-65K PTB.IES

Calculation Summary										
Label	CalcType	Units	Avg	Max	Min	Avg/Min	Max/Min	Description	PtSpcLr	PtSpcTb
SLOPE	Illuminance	Fc	1.22	13.7	0.0	N.A.	N.A.	readings taken at grade	20	20

NOTES:

- 1) EXACT MOUNTING DETAILS TO BE DETERMINED AT JOBSITE BY OTHERS.
- 2) CALCULATIONS DO NOT SHOW THE EFFECT OF SHADOWING CAUSED BY OBJECTS WITHIN THE AREA.
- 3) READINGS SHOWN ARE MAINTAINED HORIZONTAL FOOTCANDLES TAKEN AS SHOWN IN NUMERIC SUMMARY
- 4) FIXTURE ORIENTATION IS SUCH THAT 0 IS TO THE RIGHT OF THE DRAWING AND 90 IS TO THE TOP OF THE DRAWING AS SHOWN.
- 5) TILT ANGLE IS THE RAISING AND LOWERING OF THE FIXTURE HEAD.
- 6) THE LAYOUT DRAWING MUST BE COORDINATED WITH THE SITE LOCATION FOR CORRECT FIXTURE ORIENTATION.
- 7) CHECK GRAPHIC SCALE. DOCUMENTS PRINTED OR PLOTTED FROM ELECTRONIC FILES MAY OCCUR AT OTHER THAN THE DESIRED OR ASSUMED GRAPHIC SCALES. IT IS THE RESPONSIBILITY OF THE RECIPIENT TO VERIFY THAT THE PRINTED OR PLOTTED-TO-SCALE DRAWING IS PRINTED TO SCALE.
- 8) LUMINAIRE LUMENS = LUMENS LEAVING LUMINAIRE WITH EFFICIENCY CONSIDERED.
- 9) IMAGE USED FOR SITE PLAN. BECAUSE OF IMAGE QUALITY SCALE MUST BE CONFIRMED ON-SITE. REFER TO DIMENSION SHOWN ON IMAGE FOR VERIFICATION.

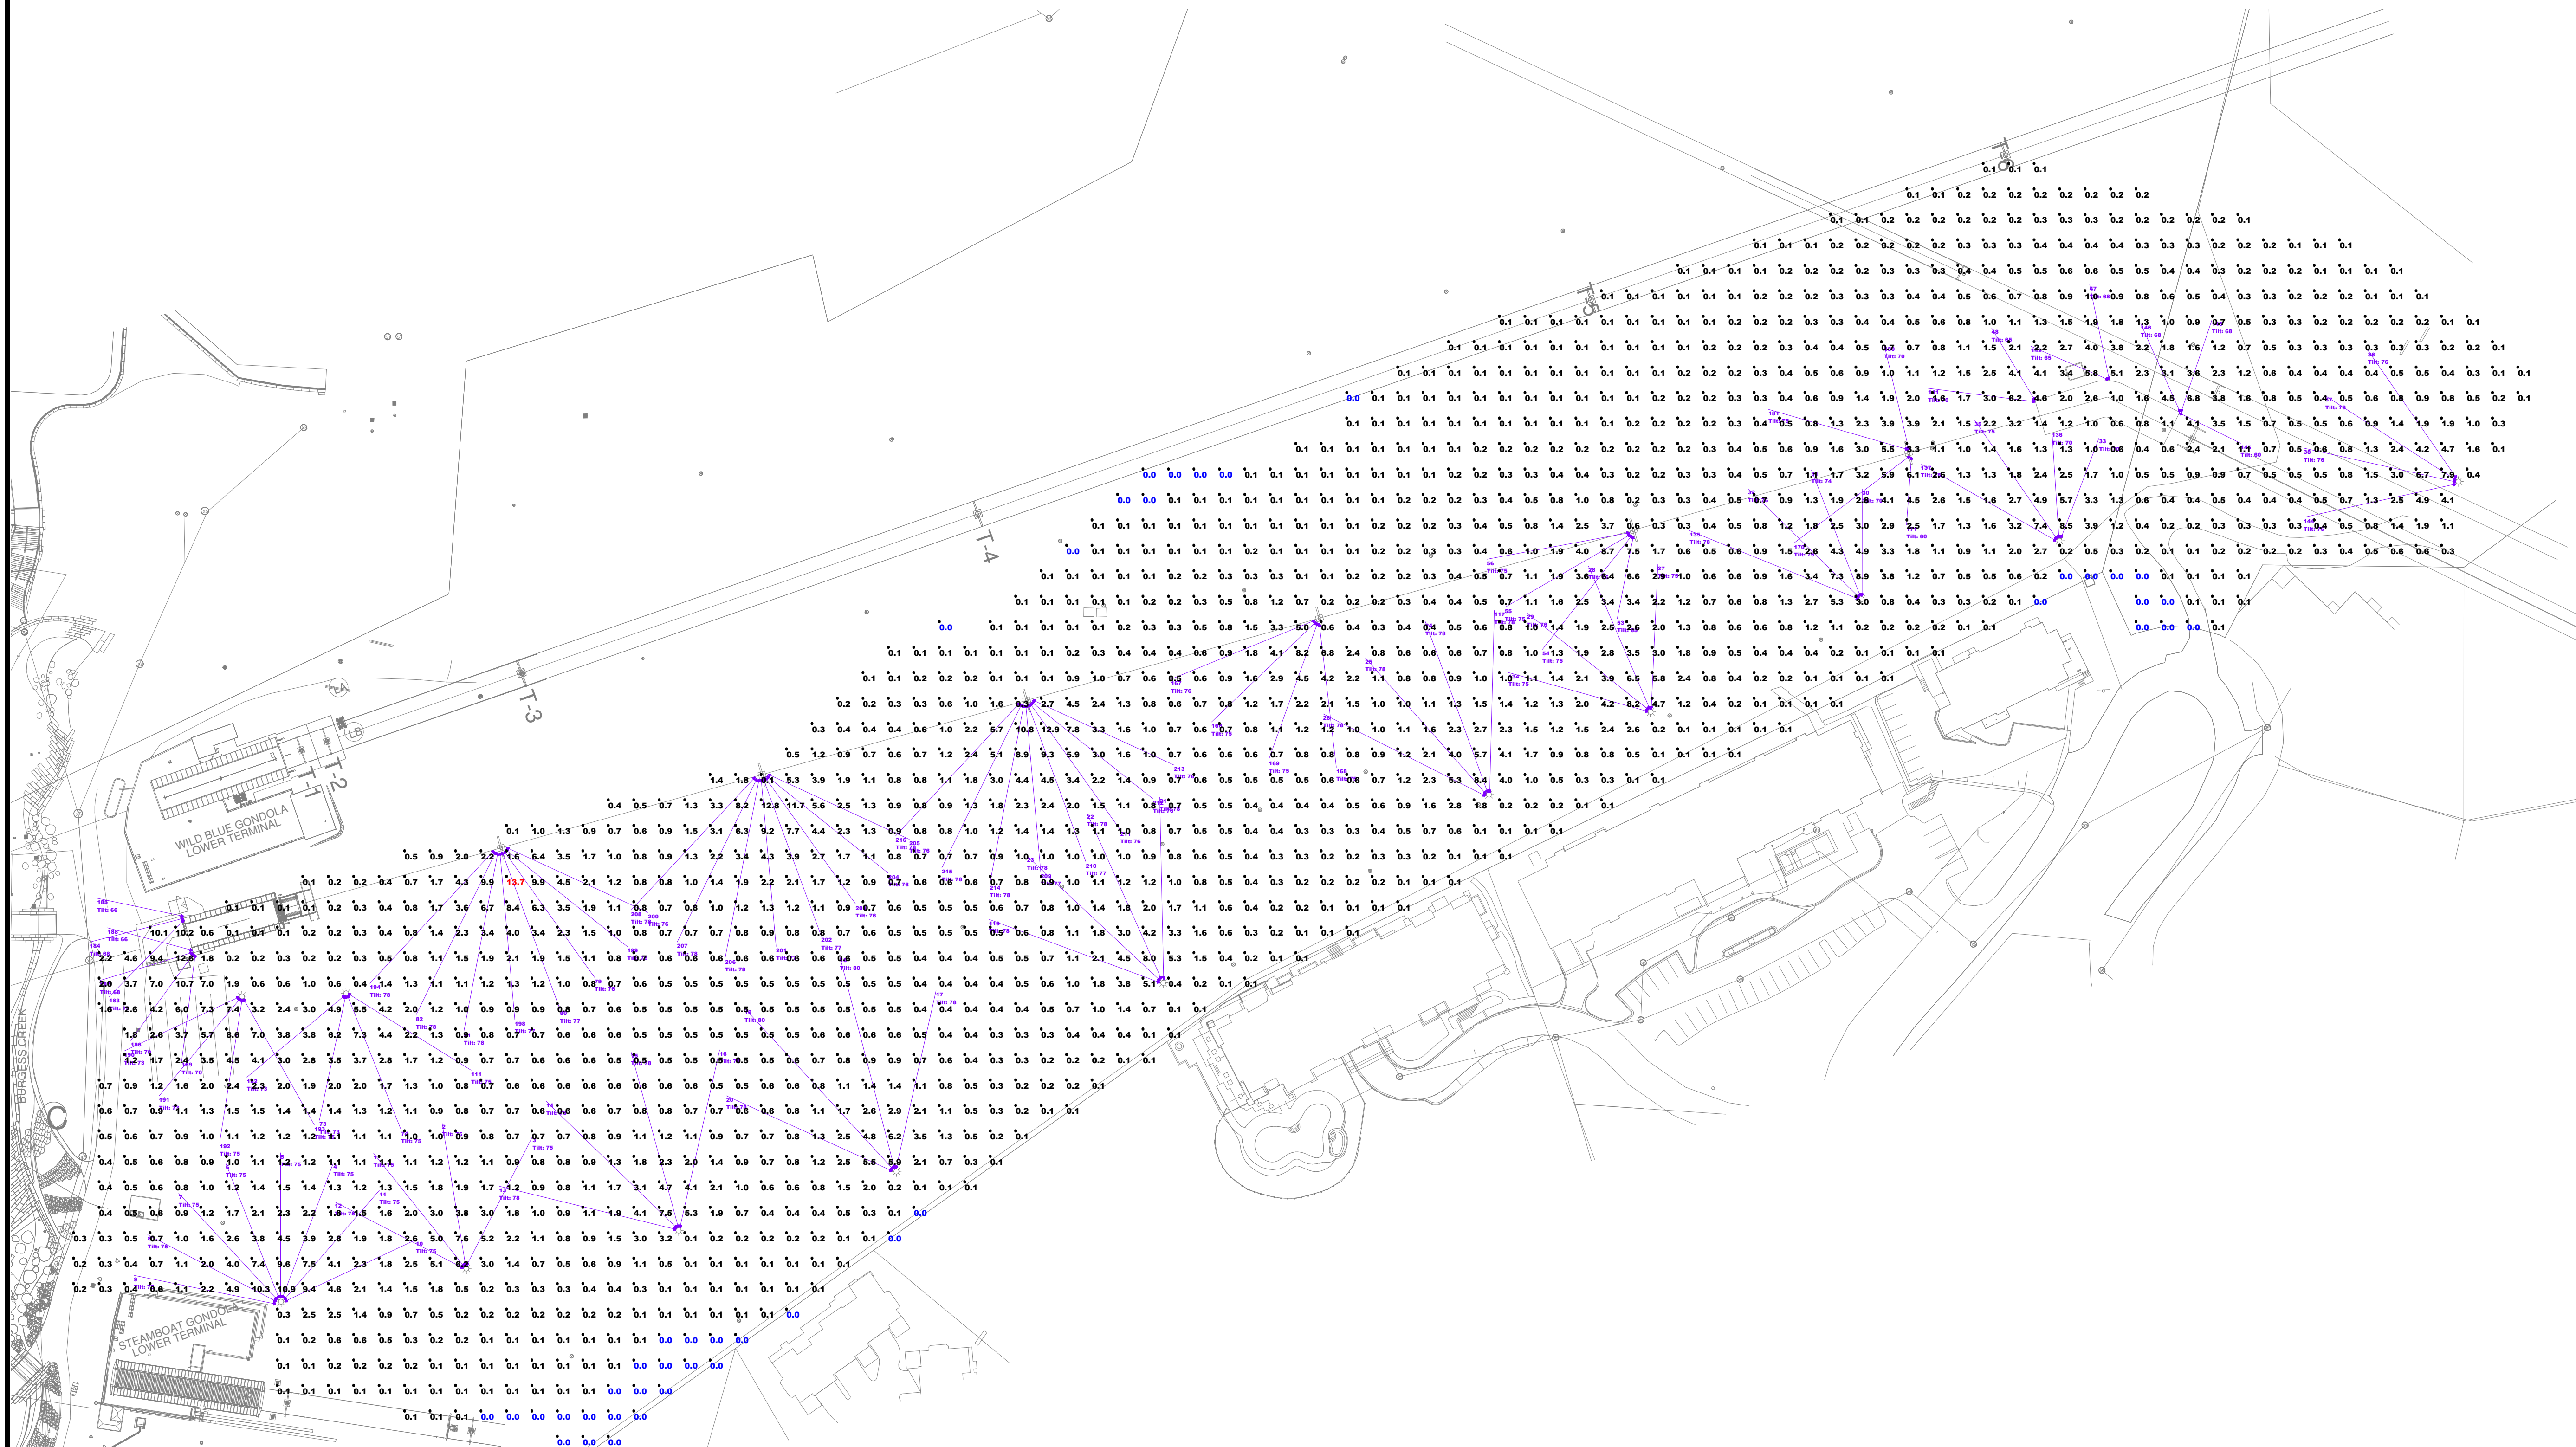

View_1:PLAN
Scale: 1 inch= 70 Ft.

STEAMBOAT SKI RESORT STEAMBOAT SPRINGS, CO
REVISED LIGHTING LAYOUT FOR SLOPES
USING GIVEN LUMINAIRE LOCATIONS

DESIGNED BY:
J. DURAN

SCALE AS SHOWN

REFERENCE UTL068G.AGI
AGi32® Version 20.6.2

Page 1 of 1

DATE 4/15/2022

